

Northeast Metropolitan Regional Vocational High School

Wakefield, MA 01880
DRA PROJECT NO. 20202



CIVIL	
NUMBER	DRAWING NAME
C-100	CIVIL NOTES, LEGENDS AND ABBREV
C-200	UTILITY DEMO PLAN
C-201	UTILITY DEMO PLAN
C-202	UTILITY DEMO PLAN
C-203	UTILITY DEMO PLAN
C-204	UTILITY DEMO PLAN
C-205	UTILITY DEMO PLAN
C-206	UTILITY DEMO PLAN
C-207	UTILITY DEMO PLAN
C-300	UTILITY SITE PLAN
C-301	UTILITY SITE PLAN
C-302	UTILITY SITE PLAN
C-303	UTILITY SITE PLAN
C-304	UTILITY SITE PLAN
C-305	UTILITY SITE PLAN
C-306	UTILITY SITE PLAN
C-307	UTILITY SITE PLAN
C-501	CIVIL SITE DETAILS
C-502	CIVIL SITE DETAILS
C-503	CIVIL SITE DETAILS
C-504	CIVIL SITE DETAILS
C-505	CIVIL SITE DETAILS

TRAFFIC	
NUMBER	DRAWING NAME
TR-001	FARM STREET AT SITE DRIVEWAY

LANDSCAPE	
NUMBER	DRAWING NAME
R-100	SITE PLAN RENDERING
L101	DEMO AND SITE PREPARATION PLAN
L102	DEMO AND SITE PREPARATION PLAN
L103	DEMO AND SITE PREPARATION PLAN
L104	DEMO AND SITE PREPARATION PLAN
L105	DEMO AND SITE PREPARATION PLAN
L301	LAYOUT AND MATERIALS PLAN
L302	LAYOUT AND MATERIALS PLAN
L303	LAYOUT AND MATERIALS PLAN
L304	LAYOUT AND MATERIALS PLAN
L305	LAYOUT AND MATERIALS PLAN
L400	SITE PLAN RENDERING
L401	GRADING PLAN
L402	GRADING PLAN
L403	GRADING PLAN
L404	GRADING PLAN
L405	GRADING PLAN
L501	PLANTING PLAN
L502	PLANTING PLAN
L503	PLANTING PLAN
L504	PLANTING PLAN
L505	PLANTING PLAN
L601	LANDSCAPE DETAILS

ARCHITECTURAL	
NUMBER	DRAWING NAME
A0-1-1	COVER SHEET
A1-0-0	PARTITION TYPES
A1-0-1	OVERALL LOWER LEVEL & FIRST FLOOR PLANS
A1-0-2	OVERALL SECOND FLOOR PLAN
A1-0-3	OVERALL THIRD FLOOR PLAN
A1-0-4	OVERALL FOURTH FLOOR PLAN
A1-0-5	OVERALL ROOF PLAN
A1-0-6	EXTERIOR RENDERINGS
A1-0-7	INTERIOR RENDERINGS
A1-0-8	LOWER & FIRST FLOOR NET AREA PLANS
A1-0-9	SECOND & THIRD FLOOR NET AREA PLANS
A1-0-10	FOURTH FLOOR & SATELITE LOCKERS NET AREA PLANS
A1-1-0C	LOWER LEVEL FLOOR PLAN - AREA C
A1-1-0D	LOWER LEVEL FLOOR PLAN - AREA D
A1-1-0MC	LOWER LEVEL MEZZANINE PLAN - AREA C
A1-1-1A	FIRST FLOOR PLAN - AREA A
A1-1-1B	FIRST FLOOR PLAN - AREA B
A1-1-1C	FIRST FLOOR PLAN - AREA C
A1-1-1D	FIRST FLOOR PLAN - AREA D
A1-1-1MA	FIRST FLOOR MEZZANINE PLAN - AREA A
A1-1-1MB	FIRST FLOOR MEZZANINE PLAN - AREA B
A1-1-2A	SECOND FLOOR PLAN - AREA A
A1-1-2B	SECOND FLOOR PLAN - AREA B
A1-1-2C	SECOND FLOOR PLAN - AREA C
A1-1-2D	SECOND FLOOR PLAN - AREA D
A1-1-3A	THIRD FLOOR PLAN - AREA A
A1-1-3B	THIRD FLOOR PLAN - AREA B
A1-1-3C	THIRD FLOOR PLAN - AREA C
A1-1-3D	THIRD FLOOR PLAN - AREA D
A1-1-4A	FOURTH FLOOR PLAN - AREA A
A1-1-4B	FOURTH FLOOR PLAN - AREA B
A1-1-4C	FOURTH FLOOR PLAN - AREA C
A1-1-4D	FOURTH FLOOR PLAN - AREA D
A1-1-CB	CONCESSION BUILDING DRAWINGS
A1-1-LB	LOCKER BUILDING DRAWINGS
A1-1-MB	MAINTENANCE BUILDING DRAWINGS
A1-2-1A	ROOF PLAN - AREA A
A1-2-1B	ROOF PLAN - AREA B
A1-2-1C	ROOF PLAN - AREA C
A1-2-1D	ROOF PLAN - AREA D
A2-0-1	OVERALL BUILDING ELEVATIONS
A2-1-1	BUILDING ELEVATIONS
A2-1-2	BUILDING ELEVATIONS
A2-1-3	BUILDING ELEVATIONS
A2-1-4	BUILDING ELEVATIONS
A2-1-5	BUILDING ELEVATIONS
A2-1-6	BUILDING ELEVATIONS
A2-1-7	BUILDING ELEVATIONS
A2-1-8	BUILDING ELEVATIONS

ARCHITECTURAL	
NUMBER	DRAWING NAME
A2-2-1	INTERIOR ELEVATIONS
A2-2-2	INTERIOR ELEVATIONS
A2-2-3	INTERIOR ELEVATIONS
A2-2-4	INTERIOR ELEVATIONS
A2-2-5	INTERIOR ELEVATIONS
A2-2-6	INTERIOR ELEVATIONS
A2-2-7	INTERIOR ELEVATIONS
A2-2-8	INTERIOR ELEVATIONS
A2-2-9	INTERIOR ELEVATIONS
A2-2-10	INTERIOR ELEVATIONS
A2-2-11	INTERIOR ELEVATIONS
A2-2-12	INTERIOR ELEVATIONS
A3-1-1	BUILDING SECTIONS
A3-1-2	BUILDING SECTIONS
A3-1-3	BUILDING SECTIONS
A3-1-4	BUILDING SECTIONS
A3-1-5	BUILDING SECTIONS
A3-1-6	BUILDING SECTIONS
A3-2-1	WALL SECTIONS
A3-2-2	WALL SECTIONS
A3-2-3	WALL SECTIONS
A3-2-4	WALL SECTIONS
A3-2-5	WALL SECTIONS
A3-2-6	WALL SECTIONS
A3-2-7	Unnamed
A3-2-8	Unnamed
A3-3-1	VERTICAL DETAILS
A4-1-1	LOCKER ROOM PLANS
AF1-0-1	FLOOR FINISH MATERIAL PLAN - LOWER & MAIN LEVEL
AF1-0-2	FLOOR FINISH MATERIAL PLAN - SECOND FLOOR LEVEL
AF1-0-3	FLOOR FINISH MATERIAL PLAN - THIRD FLOOR LEVEL
AF1-0-4	FLOOR FINISH MATERIAL PLAN - FOURTH FLOOR LEVEL
AF1-1-LB	LOCKER BUILDING FINISH PLANS
AF2-0-1	WALL FINISH MATERIAL PLAN - LOWER & MAIN LEVEL
AF2-0-2	WALL FINISH MATERIAL PLAN - SECOND LEVEL
AF2-0-3	WALL FINISH MATERIAL PLAN - THIRD LEVEL
AF2-0-4	WALL FINISH MATERIAL PLAN - FOURTH LEVEL
AF8-0-1	CEILING FINISH MATERIAL PLAN - LOWER & MAIN LEVEL
AF8-0-2	CEILING FINISH MATERIAL PLAN - SECOND FLOOR
AF8-0-3	CEILING FINISH MATERIAL PLAN - THIRD FLOOR
AF8-0-4	CEILING FINISH MATERIAL PLAN - FOURTH FLOOR

EQUIPMENT	
NUMBER	DRAWING NAME
EQ-0	NOTES, SCHEDULES, & ABBREVIATIONS
EQ-0-1C	BASEMENT FLOOR PLAN PART C
EQ-0-1D	BASEMENT FLOOR PLAN PART D
EQ-1-1A	FIRST FLOOR PLAN PART A
EQ-1-1B	FIRST FLOOR PLAN PART B
EQ-1-1C	FIRST FLOOR PLAN PART C
EQ-1-1D	FIRST FLOOR PLAN PART D
EQ-1-2A	SECOND FLOOR PART A
EQ-1-2B	SECOND FLOOR PLAN PART B
EQ-1-2C	SECOND FLOOR PLAN PART C
EQ-1-2D	SECOND FLOOR PLAN PART D
EQ-1-3A	THIRD FLOOR PLAN PART A
EQ-1-3B	THIRD FLOOR PLAN PART B
EQ-1-3C	THIRD FLOOR PLAN PART C
EQ-1-3D	THIRD FLOOR PLAN PART D
EQ-1-4A	FOURTH FLOOR PLAN PART A
EQ-1-4B	FOURTH FLOOR PLAN PART B
EQ-2-1	GYMNASIUM DETAILS
EQ-3-0	METAL FAB
EQ-3-1	AUTO TECH & AUTO COLLISION
EQ-3-2	COSMETOLOGY
EQ-3-3	CARPENTRY
EQ-3-4	PLUMBING
EQ-3-5	HVAC
EQ-3-6	ELECTRICAL
EQ-3-7	DESIGN & VISUAL COMMUNICATIONS AND DRAFTING & DESIGN
EQ-3-8	BIOTECHNOLOGY
EQ-3-9	HEALTH ASSISTING
EQ-3-11	MEDICAL ASSISTING
EQ-3-12	DENTAL
EQ-3-12	ROBOTICS & AUTOMATION
EQ-4-1	CASEWORK

STRUCTURAL	
NUMBER	DRAWING NAME
S1-1-0C	LOWER LEVEL FOUNDATION PLAN - AREA C
S1-1-0D	LOWER LEVEL FOUNDATION PLAN - AREA D
S1-1-1A	FIRST FLOOR FOUNDATION PLAN - AREA A
S1-1-1B	FIRST FLOOR FOUNDATION PLAN - AREA B
S1-1-1C	FIRST FLOOR FOUNDATION PLAN - AREA C
S1-1-1D	FIRST FLOOR FOUNDATION PLAN - AREA D
S1-1-2A	SECOND FLOOR FRAMING PLAN - AREA A
S1-1-2B	SECOND FLOOR FRAMING PLAN - AREA B
S1-1-2C	SECOND FLOOR FRAMING PLAN - AREA C
S1-1-2D	SECOND FLOOR FRAMING PLAN - AREA D
S1-1-3A	THIRD FLOOR FRAMING PLAN - AREA A
S1-1-3B	THIRD FLOOR FRAMING PLAN - AREA B
S1-1-3C	THIRD FLOOR FRAMING PLAN - AREA C
S1-1-3D	THIRD FLOOR FRAMING PLAN - AREA D
S1-1-4A	FOURTH FLOOR FRAMING PLAN - AREA A
S1-1-4B	FOURTH FLOOR FRAMING PLAN - AREA B
S1-1-4C	FOURTH FLOOR FRAMING PLAN - AREA C
S1-1-4D	FOURTH FLOOR FRAMING PLAN - AREA D
S1-1-5A	ROOF FRAMING PLAN - AREA A
S1-1-5B	ROOF FRAMING PLAN - AREA B
S1-1-5C	ROOF FRAMING PLAN - AREA C
S1-1-5D	ROOF FRAMING PLAN - AREA D


PLUMBING	
NUMBER	DRAWING NAME
P0-0-1	PLUMBING LEGENDS, ABBREVIATIONS, AND GENERAL NOTES
P1-1-0E	PLUMBING LOWER LEVEL FLOOR PLAN - PLAN EAST
P1-1-1E	PLUMBING FIRST FLOOR PLAN - PLAN EAST
P1-1-1W	PLUMBING FIRST FLOOR PLAN - PLAN WEST
P1-1-2E	PLUMBING SECOND FLOOR PLAN - PLAN EAST
P1-1-2W	PLUMBING SECOND FLOOR PLAN - PLAN WEST
P1-1-3E	PLUMBING THIRD FLOOR PLAN - PLAN EAST
P1-1-3W	PLUMBING THIRD FLOOR PLAN - PLAN WEST
P1-1-4E	PLUMBING FOURTH FLOOR PLAN - PLAN EAST
P1-1-4W	PLUMBING FOURTH FLOOR PLAN - PLAN WEST
P1-2-1E	PLUMBING ROOF PLAN - PLAN EAST
P1-2-1W	PLUMBING ROOF PLAN - PLAN WEST

FIRE PROTECTION	
NUMBER	DRAWING NAME
FP0-0-1	FIRE PROTECTION COVER SHEET
FP1-1-0E	FIRE PROTECTION LOWER LEVEL FLOOR PLAN - PLAN EAST
FP1-1-1E	FIRE PROTECTION FIRST FLOOR PLAN - PLAN EAST
FP1-1-1W	FIRE PROTECTION FIRST FLOOR PLAN - PLAN WEST
FP1-1-2E	FIRE PROTECTION SECOND FLOOR PLAN - PLAN EAST
FP1-1-2W	FIRE PROTECTION SECOND FLOOR PLAN - PLAN WEST
FP1-1-3E	FIRE PROTECTION THIRD FLOOR PLAN - PLAN EAST
FP1-1-3W	FIRE PROTECTION THIRD FLOOR PLAN - PLAN WEST
FP1-1-4E	FIRE PROTECTION FOURTH FLOOR PLAN - PLAN EAST
FP1-1-4W	FIRE PROTECTION FOURTH FLOOR PLAN - PLAN WEST
FP1-2-1E	FIRE PROTECTION ROOF PLAN - PLAN EAST
FP1-2-1W	FIRE PROTECTION ROOF PLAN - PLAN WEST

MECHANICAL	
NUMBER	DRAWING NAME
M0-0-1	MECHANICAL LEGENDS, ABBREVIATIONS, AND GENERAL NOTES
M0-0-2	HVAC ZONING PLAN
M0-0-3	HVAC ZONING PLAN
M1-1-0	HVAC LOWER LEVEL FLOOR PLAN
M1-1-1E	HVAC FIRST FLOOR PLAN - PLAN EAST
M1-1-1W	HVAC FIRST FLOOR PLAN - PLAN WEST
M1-1-2E	HVAC SECOND FLOOR PLAN - PLAN EAST
M1-1-2W	HVAC SECOND FLOOR PLAN - PLAN WEST
M1-1-3E	HVAC THIRD FLOOR PLAN - PLAN EAST
M1-1-3W	HVAC THIRD FLOOR PLAN - PLAN WEST
M1-1-4E	HVAC FOURTH FLOOR PLAN - PLAN EAST
M1-1-4W	HVAC FOURTH FLOOR PLAN - PLAN WEST
M1-2-1E	HVAC ROOF PLAN - PLAN EAST
M1-2-1W	HVAC ROOF PLAN - PLAN WEST

ELECTRICAL	
NUMBER	DRAWING NAME
E0-0-1	ELECTRICAL TITLE SHEET (NOTES & DWG LIST)
E0-0-2	ELECTRICAL LEGENDS AND ABBREVIATIONS
E0-1-1	ELECTRICAL SITE PLAN
E0-1-2	ELECTRICAL SITE PLAN
E0-1-3	ELECTRICAL SITE PLAN
E0-1-4	SITE DETAILS
E0-1-5	SITE DETAILS
E0-1-6	TYPICAL EVSE DETAILS
E0-1-7	TYPICAL SPORTS LIGHTING DETAILS
E1-1-0E	ELECTRICAL LOWER LEVEL FLOOR PLAN - PLAN EAST
E1-1-1E	ELECTRICAL FIRST FLOOR PLAN - PLAN EAST
E1-1-1W	ELECTRICAL FIRST FLOOR PLAN - PLAN WEST
E1-1-2E	ELECTRICAL SECOND FLOOR PLAN - PLAN EAST
E1-1-2W	ELECTRICAL SECOND FLOOR PLAN - PLAN WEST
E1-1-3E	ELECTRICAL THIRD FLOOR PLAN - PLAN EAST
E1-1-3W	ELECTRICAL THIRD FLOOR PLAN - PLAN WEST
E1-1-4E	ELECTRICAL FOURTH FLOOR PLAN - PLAN EAST
E1-1-4W	ELECTRICAL FOURTH FLOOR PLAN - PLAN WEST
E1-2-1E	ELECTRICAL ROOF PLAN - PLAN EAST
E1-2-1W	ELECTRICAL ROOF PLAN - PLAN WEST
E2-0-1	MAIN POWER ONE LINE DIAGRAM
E2-0-2	MECHANICAL POWER ONE LINE DIAGRAM
E2-0-3	NORMAL POWER ONE LINE DIAGRAM
E2-0-4	EMERGENCY POWER ONE LINE DIAGRAM
E2-0-5	ELECTRICAL POWER SCHEDULES
E3-0-1	GROUNDING DETAILS
E3-0-2	GENERAL DETAILS
E3-0-3	CONTROL DETAILS
E4-0-1	ELECTRICAL DETAIL SHEET 1
E4-0-2	ELECTRICAL DETAIL SHEET 2
E4-0-3	ELECTRICAL DETAIL SHEET 3
E4-0-4	COMMUNICATIONS RISER DIAGRAM
E4-0-5	ELECTRICAL THEATRICAL LIGHTING RISER DIAGRAM

TECHNOLOGY	
NUMBER	DRAWING NAME
T0-0-0	TECHNOLOGY, SECURITY & AUDIOVISUAL SYMBOL LIST
T1-1-0C	LOWER LEVEL FLOOR PLAN - AREA C TECHNOLOGY & SECURITY
T1-1-0D	LOWER LEVEL FLOOR PLAN - AREA D TECHNOLOGY & SECURITY
T1-1-1A	FIRST FLOOR PLAN - AREA A TECHNOLOGY & SECURITY
T1-1-1B	FIRST FLOOR PLAN - AREA B TECHNOLOGY & SECURITY
T1-1-1C	FIRST FLOOR PLAN - AREA C TECHNOLOGY & SECURITY
T1-1-1D	FIRST FLOOR PLAN - AREA D TECHNOLOGY & SECURITY
T1-1-2A	SECOND FLOOR PLAN - AREA A TECHNOLOGY & SECURITY
T1-1-2B	SECOND FLOOR PLAN - AREA B TECHNOLOGY & SECURITY
T1-1-2C	SECOND FLOOR PLAN - AREA C TECHNOLOGY & SECURITY
T1-1-2D	SECOND FLOOR PLAN - AREA D TECHNOLOGY & SECURITY
T1-1-3A	THIRD FLOOR PLAN - AREA A TECHNOLOGY & SECURITY
T1-1-3B	THIRD FLOOR PLAN - AREA B TECHNOLOGY & SECURITY
T1-1-3C	THIRD FLOOR PLAN - AREA C TECHNOLOGY & SECURITY
T1-1-3D	THIRD FLOOR PLAN - AREA D TECHNOLOGY & SECURITY
T1-1-4A	FOURTH FLOOR PLAN - AREA A TECHNOLOGY & SECURITY
T1-1-4B	FOURTH FLOOR PLAN - AREA B TECHNOLOGY & SECURITY
T1-1-4C	FOURTH FLOOR PLAN - AREA C TECHNOLOGY & SECURITY
T1-1-4D	FOURTH FLOOR PLAN - AREA D TECHNOLOGY & SECURITY
T1-1-5	OUTBUILDING PLANS TECHNOLOGY & SECURITY

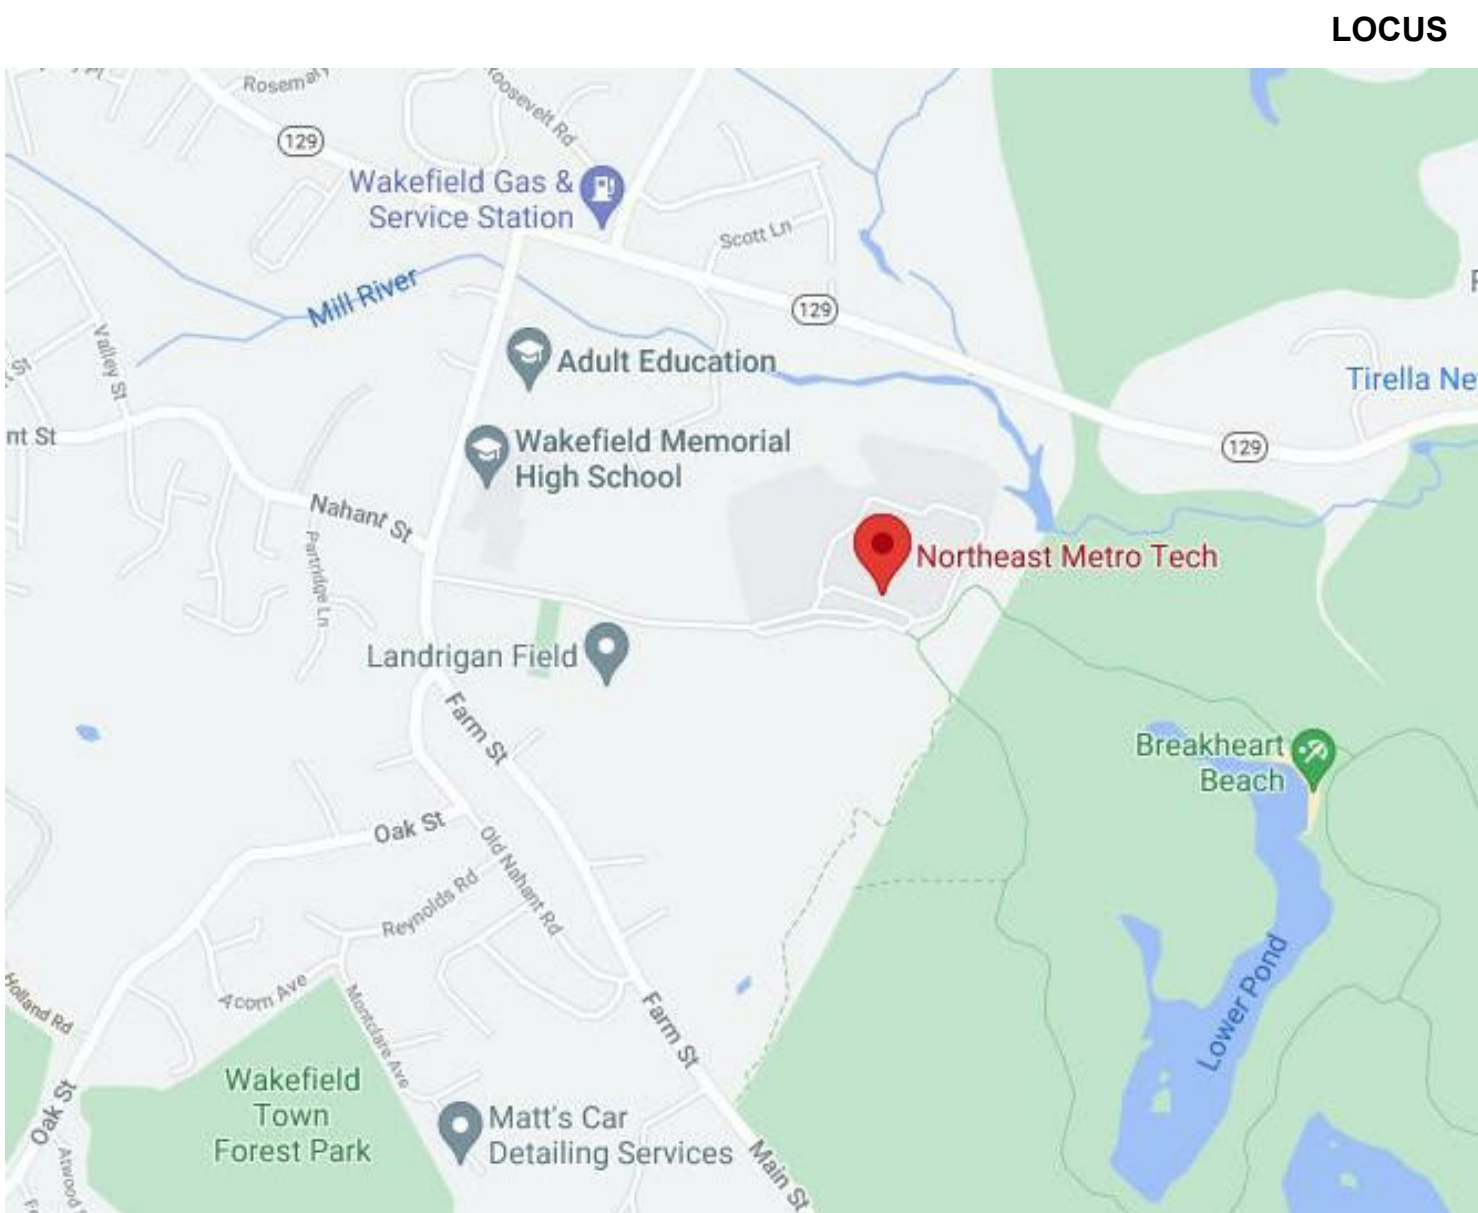

Issue Date: June 17, 2021
MSBA SCHEMATIC DESIGN SUBMISSION

ARCHITECT
Drumme Rosane Anderson
260 Charles Street, Studio 300
Waltham, MA 02453
t: 617.964.1700

LANDSCAPE ARCHITECT
Warner Larson Lanscape Architects
130 West Broadway
Boston, MA 02108
t: 617.464.1440

CIVIL ENGINEER
Nitsch Engineering
2 Center Plaze, Suite 430
Boston, MA 02108
t: 617.338.0063

STRUCTURAL ENGINEER
Engineers Design Group
350 Main St., Floor 2
Malden, MA. 02148
t: 781-396-9007

MEP-FP ENGINEER
Bala Consulting Engineers
52 Temple Place
Boston, MA 02111
t: 617-357-6060

EQUIPMENT CONSULTANT
Tavares Design Associates
591 North Avenue, Door 3
Wakefield, MA 01880
t: (781) 716-3642

TECHNOLOGY CONSULTANT
3Si, System Software Support, Inc.
168 Main Street
Northfield, MA
t: (413) 498-0069