

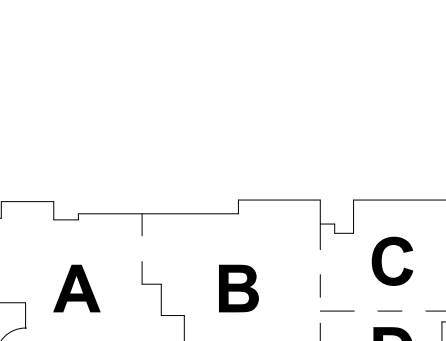
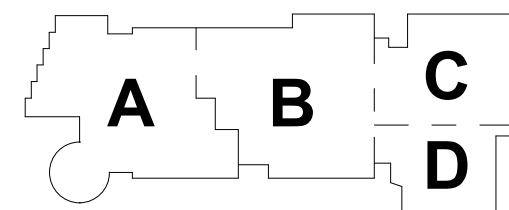


DRA	
Drumrey Rosane Anderson, Inc.	
225 Oakland Road Studio 205 South Windsor, CT 06074	280 Charles Street Studio 300 Waltham, MA 02453
Planning Architecture Interior Design	
Tel: 800.644.8300 www.dra-inc.com	
NORTHEAST METRO TECH	
100 Hemlock Rd, Wakefield, MA 01880	
BALA ENGINEERS BALA ENGINEERS, INC. 1000 W. 14th St. Suite 200 Denver, CO 80202 Tel: 303.733.1100 Fax: 303.733.1101 www.bala-engineers.com REGISTERED PROFESSIONAL ENGINEERS REGISTERED PROFESSIONAL ARCHITECTS	
MSBA SCHEMATIC DESIGN SUBMITTAL JUNE 17, 2021	
	
KEY PLAN	
PROJECT NORTH 	MAGNETIC NORTH 
PLUMBING LEGENDS, ABBREVIATIONS, AND GENERAL NOTES	
Scale: 1" = 1'-0" Sheet No.: 6020409 Drawn By: DRA Date: JUNE 17, 2021	P0-0-1

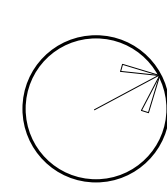

KEY PLAN

PROJECT NORTH	MAGNETIC NORTH
0	0
1	1
2	2
100	100

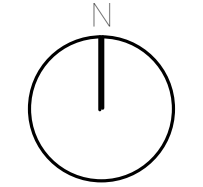


PLUMBING LEGENDS, ABBREVIATIONS AND GENERAL NOTES

Scale: 12" = 1'-0"
 Job No.: 6020409
 Drawn By: DRA
 Date: JUNE 17, 2021

P0-0-1

DRAWING LIST - PLUMBING_BOS			
DRAWING NUMBER	DRAWING TITLE	SHEET NUMBER	
		INDEX	TOTAL
P0-1	PLUMBING LEGENDS, ABBREVIATIONS, AND GENERAL NOTES		
P1-1-0E	PLUMBING LOWER LEVEL FLOOR PLAN - PLAN EAST		
P1-1-1E	PLUMBING FIRST FLOOR PLAN - PLAN EAST		
P1-1-1W	PLUMBING FIRST FLOOR PLAN - PLAN WEST		
P1-1-2E	PLUMBING SECOND FLOOR PLAN - PLAN EAST		
P1-1-2W	PLUMBING SECOND FLOOR PLAN - PLAN WEST		
P1-1-3E	PLUMBING THIRD FLOOR PLAN - PLAN EAST		
P1-1-3W	PLUMBING THIRD FLOOR PLAN - PLAN WEST		
P1-1-4E	PLUMBING FOURTH FLOOR PLAN - PLAN EAST		
P1-1-4W	PLUMBING FOURTH FLOOR PLAN - PLAN WEST		
P1-2-1E	PLUMBING ROOF PLAN - PLAN EAST		
P1-2-1W	PLUMBING ROOF PLAN - PLAN WEST		

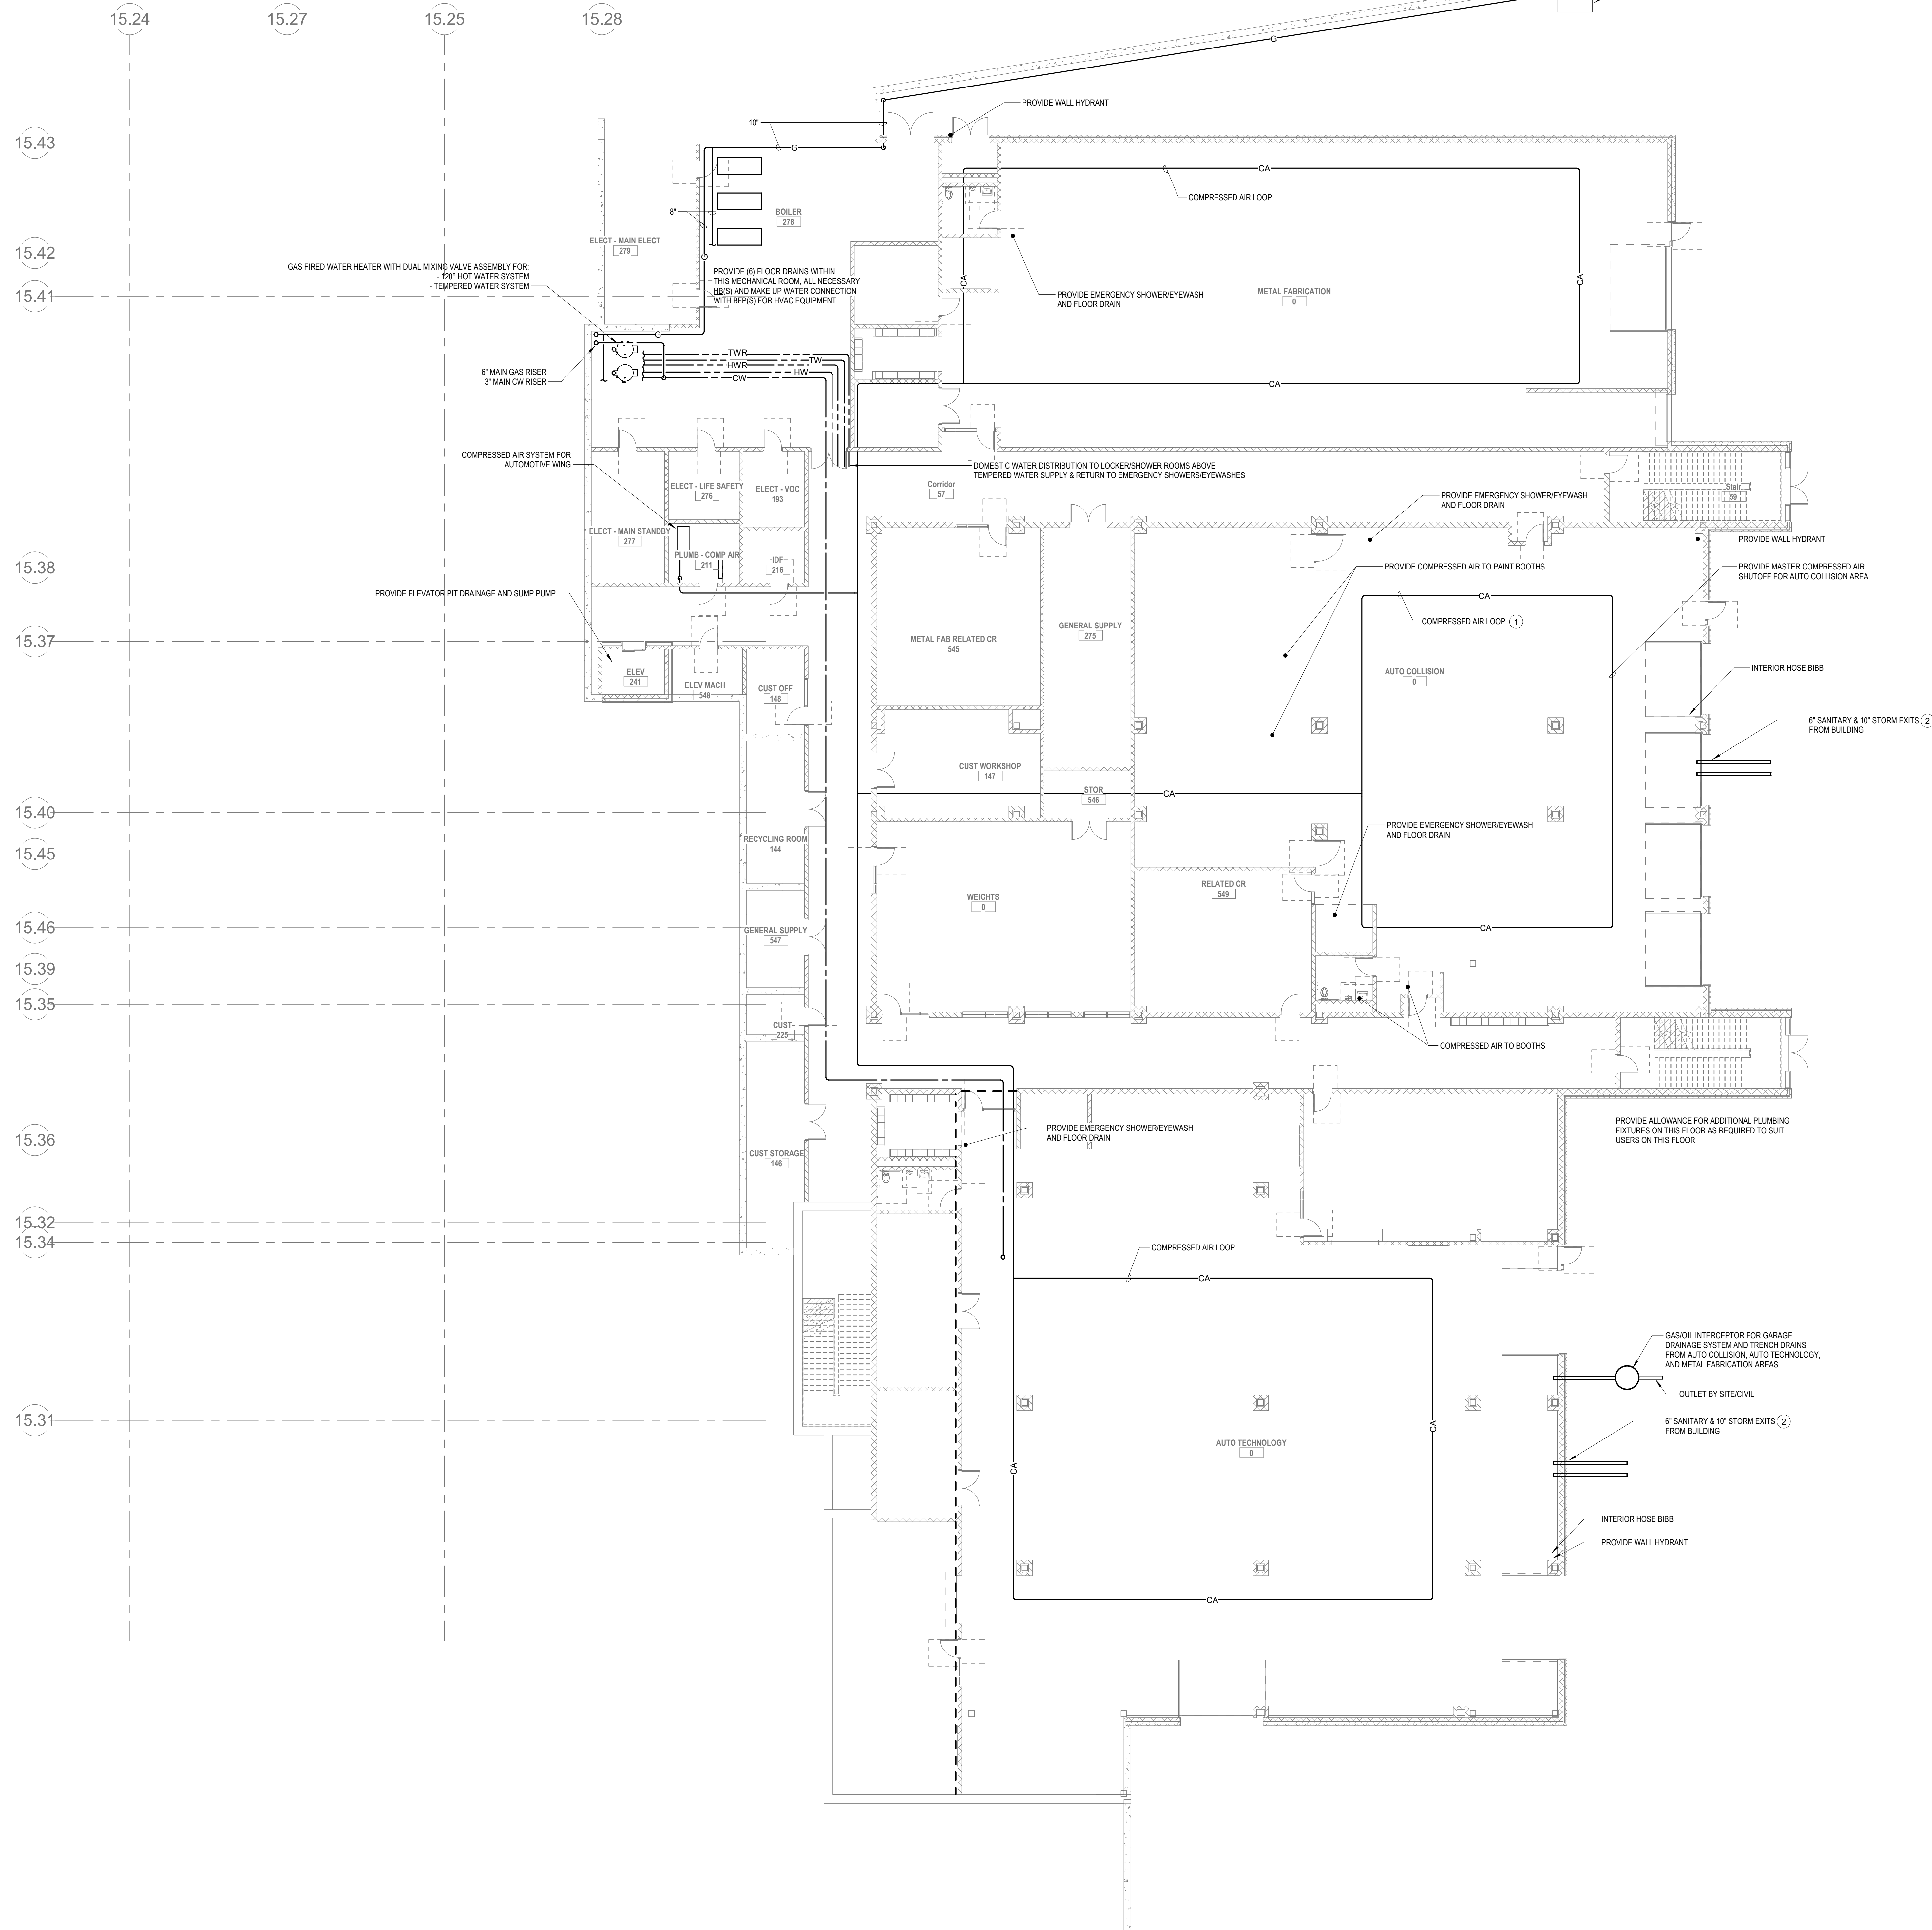

- SCOPE NOTES:
- VENTING FOR GARAGE DRAINAGE SHALL BE INDEPENDENT OF THE SANITARY VENT SYSTEM THROUGH ROOF.
 - REFER TO AUTOMOTIVE EQ DRAWINGS FOR ADDITIONAL REQUIREMENTS.
 - PROVIDE VENTING FROM LOWER LEVEL THROUGH ROOF FOR RADON MITIGATION. QUANTITY AND SIZE OF VENTING SHALL BE AS DIRECTED BY THE GEOTECHNICAL ENGINEER.
 - PROVIDE DEDICATED VENTING FROM UNDERSLAB DRAINAGE SYSTEM THROUGH ROOF.
 - PROVIDE DRAINAGE FOR OIL WASTE TO EXTERIOR TANK.
- KEY NOTES:
- OFF OF COMPRESSED AIR LOOP EXTEND COMPRESSED AIR DROP WITH ALL NECESSARY EQUIPMENT AIR OUTLET AS REQUIRED NOTED PER EQUIPMENT DRAWINGS.
 - SANITARY MAIN TO HANDLE ALL PLUMBING FIXTURES SHOWN IN THIS BUILDING SEGMENT. STORM SPAN MAIN TO HANDLE ALL ROOF DRAINS FOR THIS BUILDING SEGMENT. REFER TO ARCHITECTURAL DRAWINGS FOR QUANTITY & LOCATIONS.

DRA

Drumme Rosane Anderson, Inc.
225 Oakland Road
Studio 205
South Windsor, CT 06074
Tel: 860.644.8300
www.dra.com

260 Charles Street
Studio 300
Waltham, MA 02453
Tel: 860.644.8300
www.dra.com

Planning | Architecture | Interior Design

**NORTHEAST
METRO TECH**



100 Hemlock Rd.
Wakefield, MA 01880

BALA
ENGINEERS

REGISTERED PROFESSIONAL ENGINEERS
IN THE STATE OF MASSACHUSETTS
LICENSE NO. 100000
EXPIRATION DATE 12/31/2024

MSBA
SCHEMATIC
DESIGN
SUBMITTAL




JUNE 17, 2021

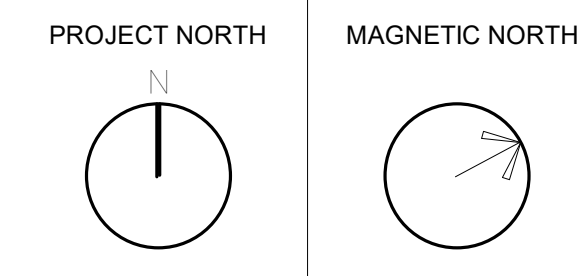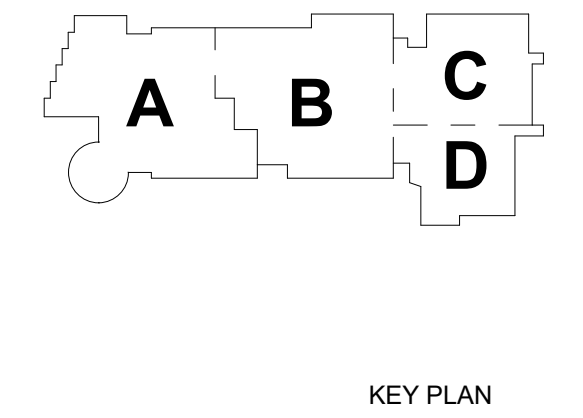


**PLUMBING
LOWER LEVEL
FLOOR PLAN -
PLAN EAST**

Scale: 3/32" = 1'-0"
Job No.: 6020409
Drawn By: DRA
Date: JUNE 17, 2021

P1-1-0E

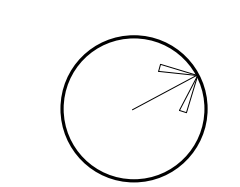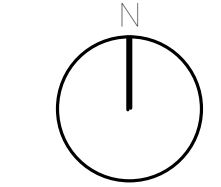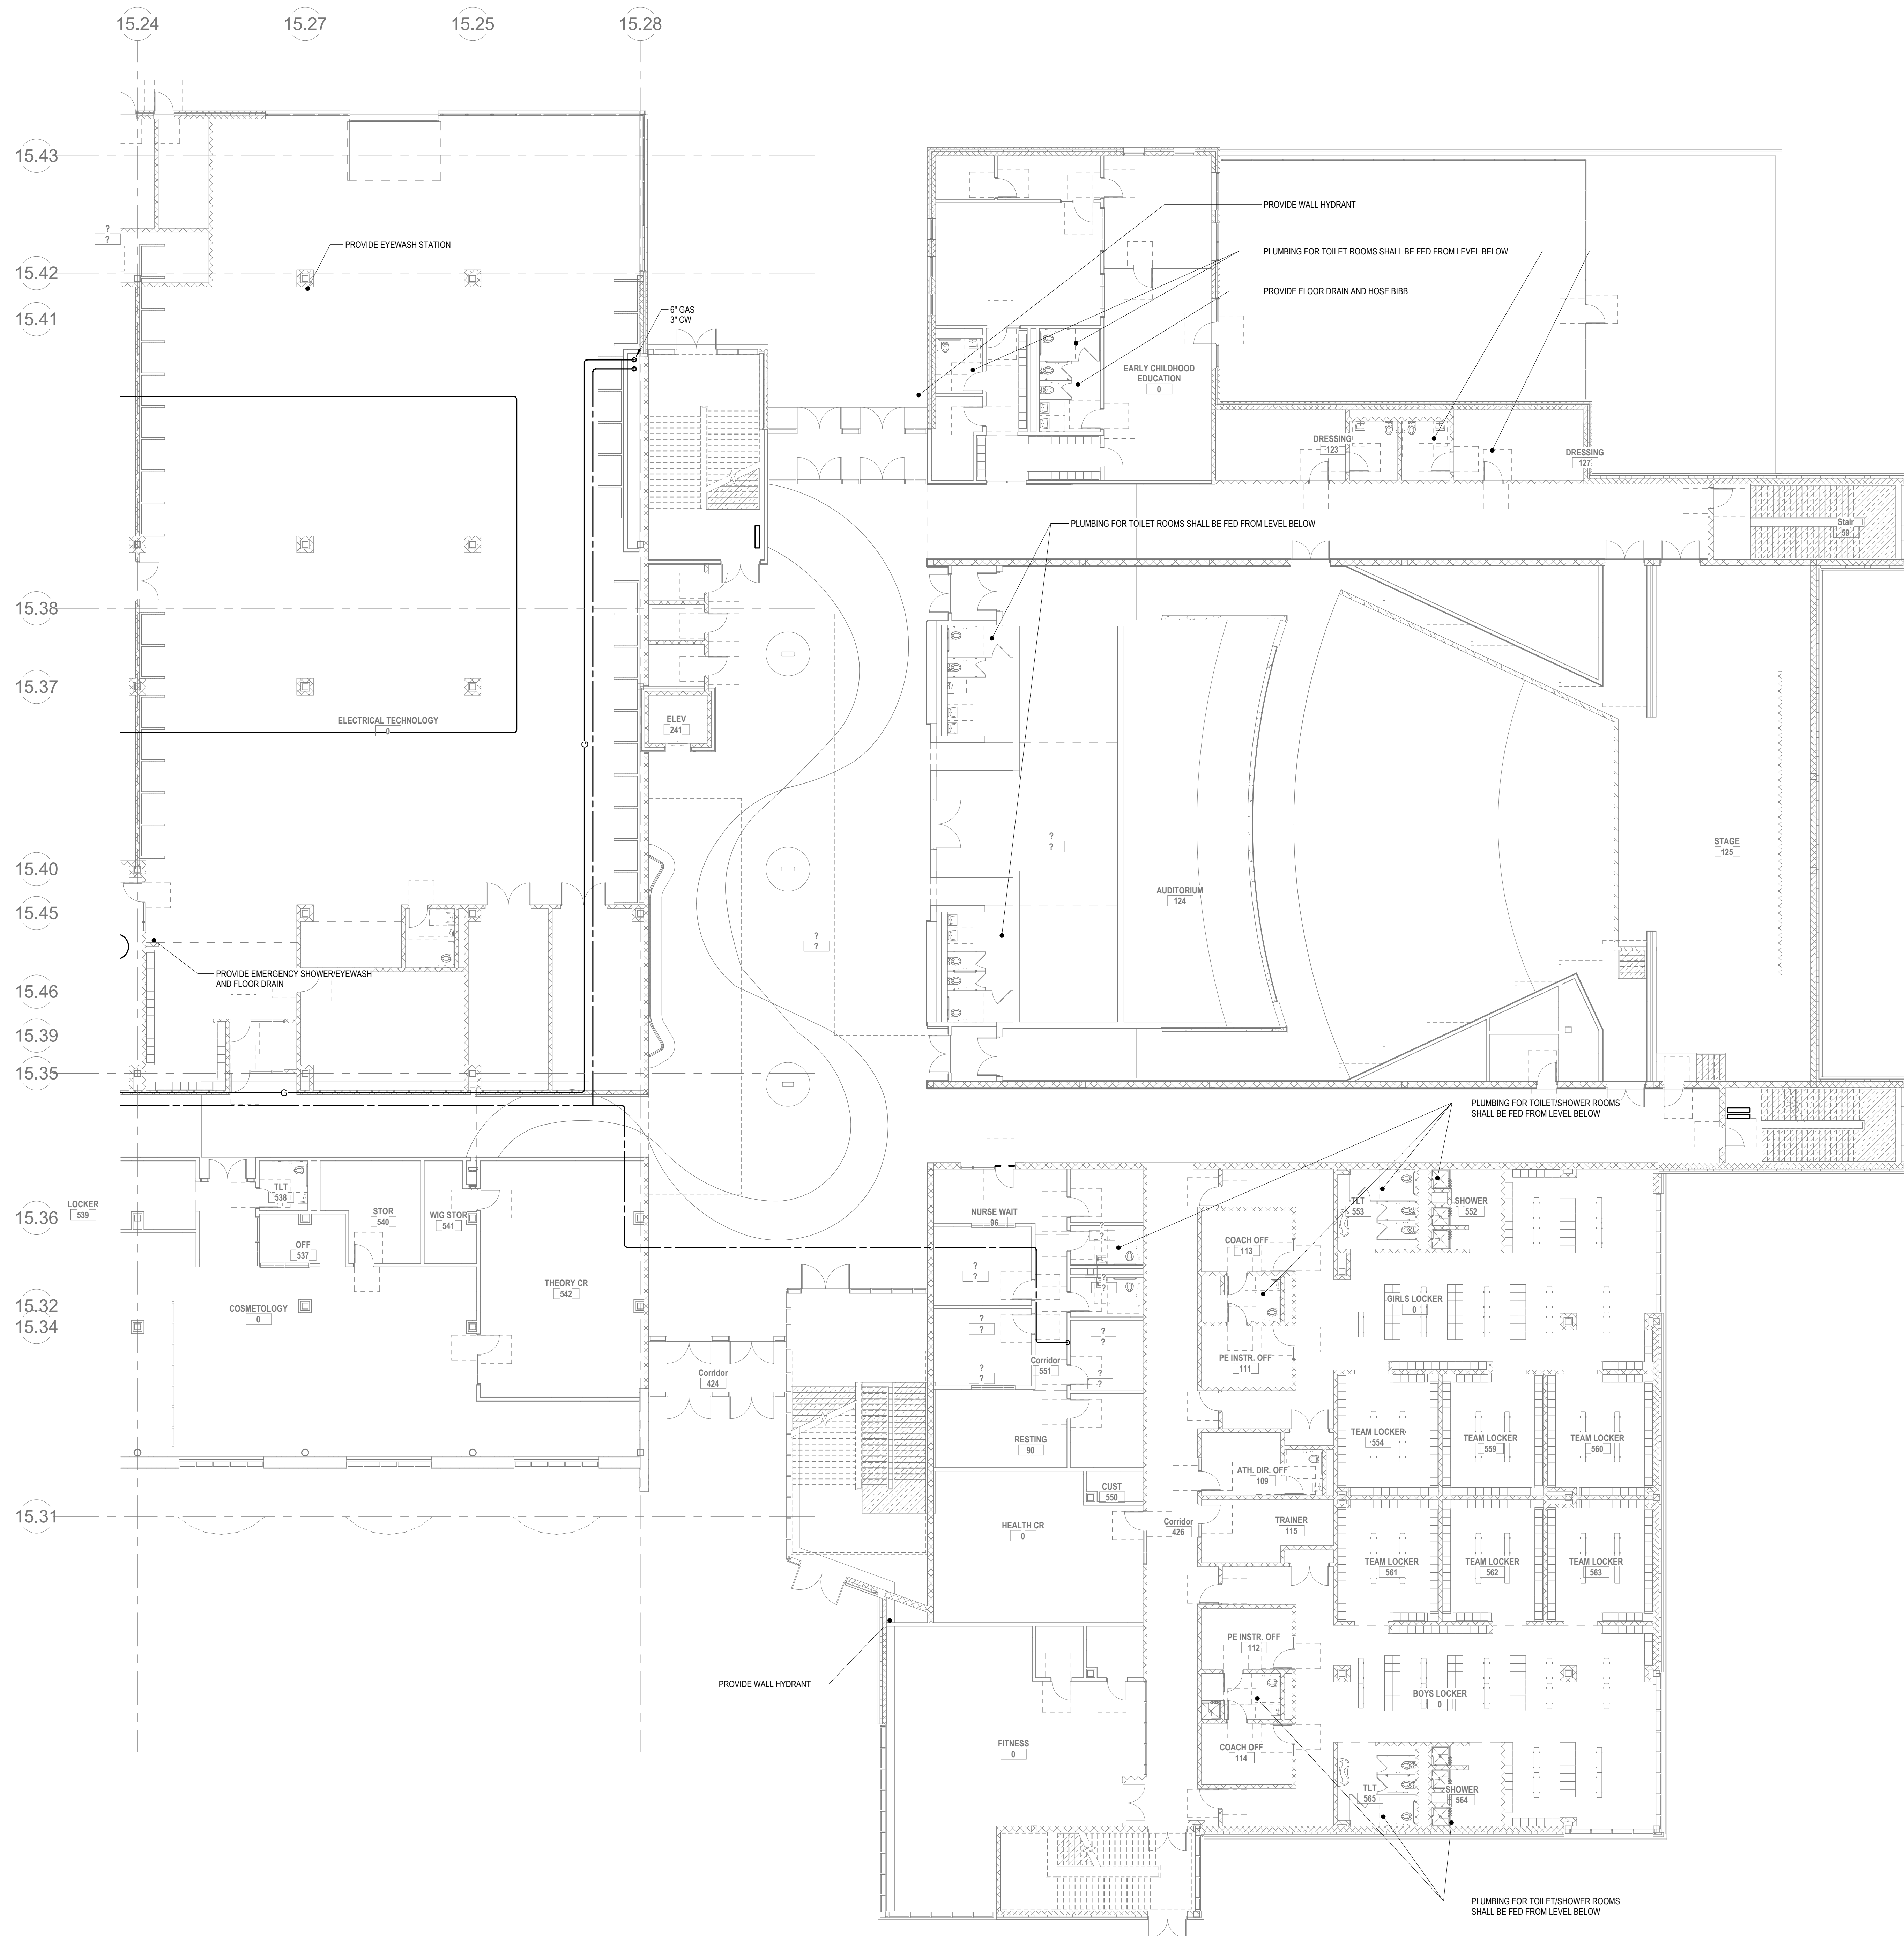

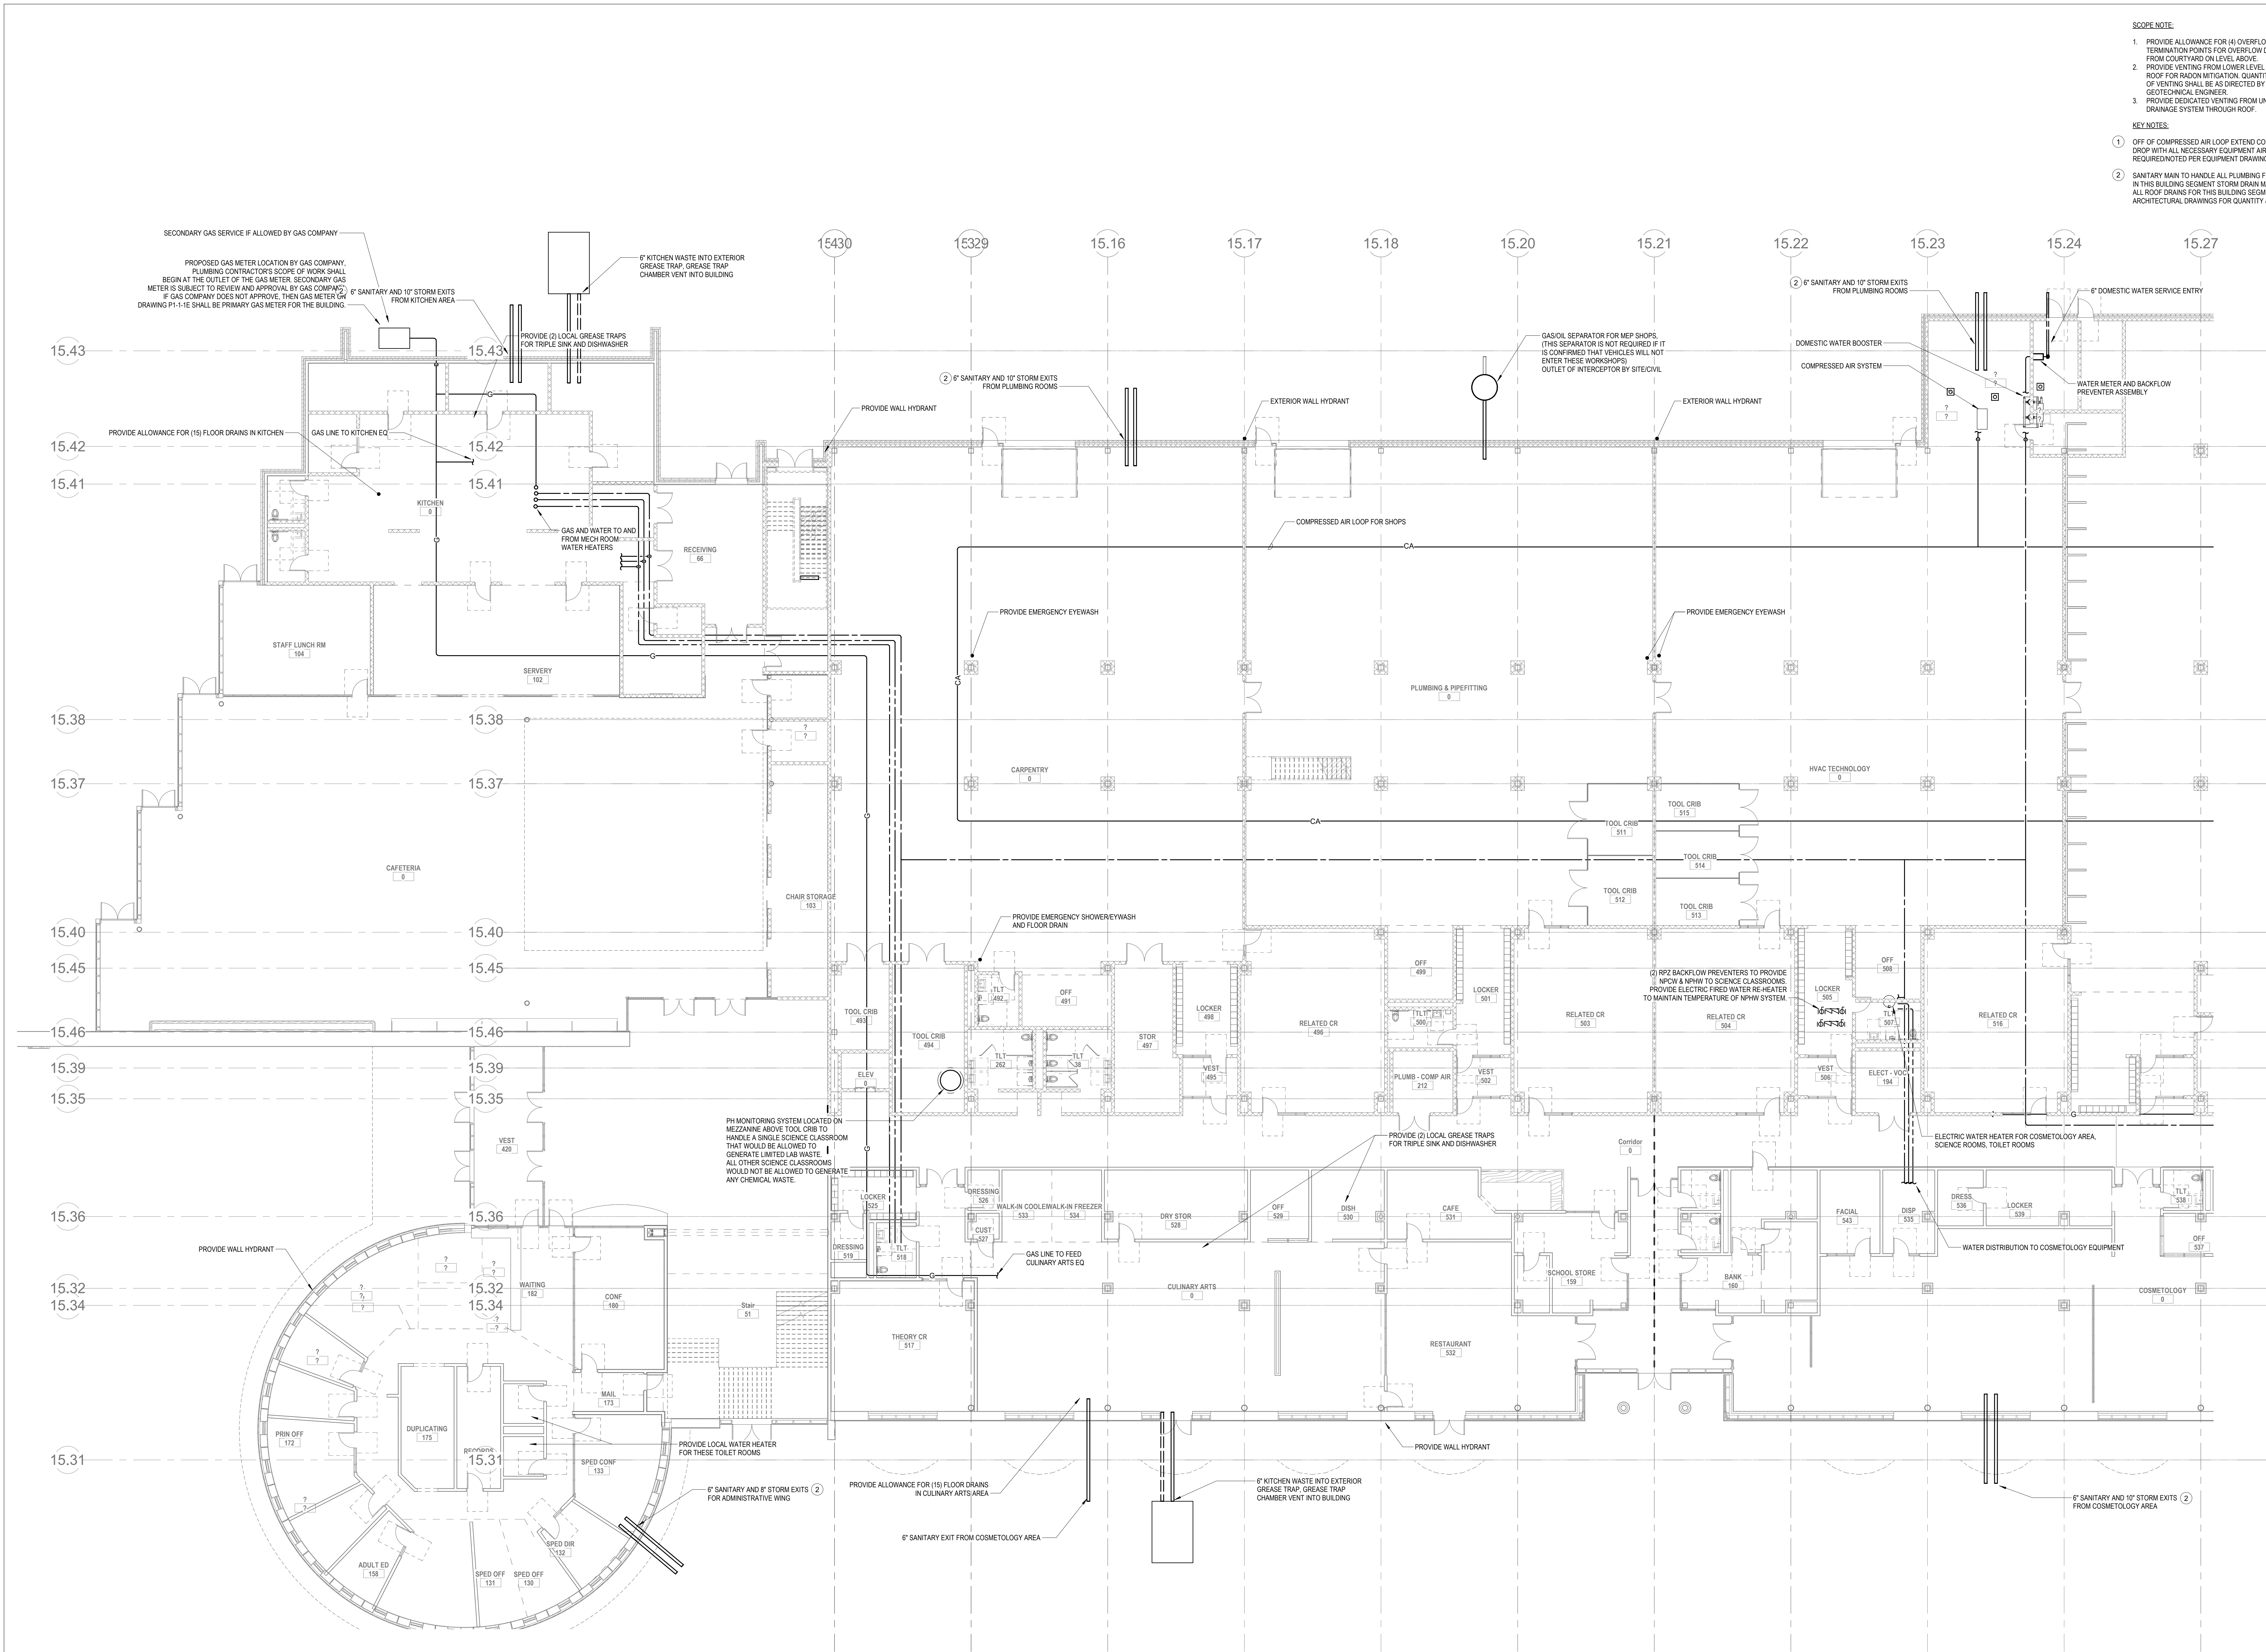

2 PLUMBING Level 1 West
3/32" = 1'-0"

SCOPE NOTE:

1. PROVIDE ALLOWANCE FOR (4) OVERFLOW DRAIN TERMINATION POINTS FOR OVERFLOW DRAINAGE FROM COURTYARD ON LEVEL ABOVE.
2. PROVIDE VENTING FROM LOWER LEVEL THROUGH ROOF FOR PACKAGING. QUANTITY AND SIZE OF VENTING SHALL BE AS DIRECTED BY THE GEOTECHNICAL ENGINEER.
3. PROVIDE DEDICATED VENTING FROM UNDERSLAB DRAINAGE SYSTEM THROUGH ROOF.

KEY NOTES:

1. OFF OF COMPRESSED AIR LOOP EXTEND COMPRESSED AIR DROP WITH ALL NECESSARY EQUIPMENT AIR OUTLET AS REQUIRED/NOTED PER EQUIPMENT DRAWINGS.
2. SANITARY MAN TO HANDLE ALL PLUMBING FIXTURES SHOWN IN THIS BUILDING SEGMENT. STORM DRAIN MAIN TO HANDLE ALL ROOF DRAINS FOR THIS BUILDING SEGMENT. REFER TO ARCHITECTURAL DRAWINGS FOR QUANTITY & LOCATIONS.

DRA

Drumme Rosane Anderson, Inc.

225 Oakland Road
Studio 205
South Windsor, CT
06074

280 Charles Street
Studio 300
Waltham, MA
02453

Planning | Architecture | Interior Design
Tel: 860.644.8300
www.dra-inc.com

NORTHEAST
METRO TECH


100 Hemlock Rd.
Wakefield, MA 01880

BALA
ENGINEERS

© COPYRIGHT 2021 DRUMME ROSANE ANDERSON, INC.


MSBA
SCHEMATIC
DESIGN
SUBMITTAL

JUNE 17, 2021

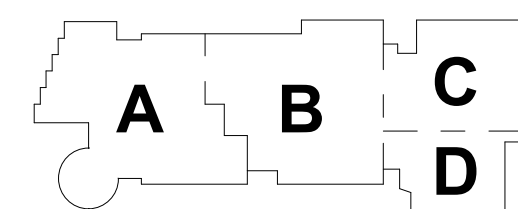


KEY PLAN

PROJECT NORTH

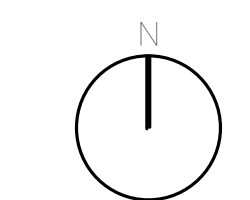

MAGNETIC NORTH

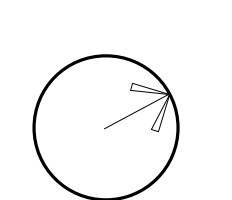

PLUMBING FIRST
FLOOR PLAN -
PLAN WEST


Scale: 3/32" = 1'-0"

Job No.: 6020409

Drawn By: DRA

Date: JUNE 17, 2021

P1-1-1W

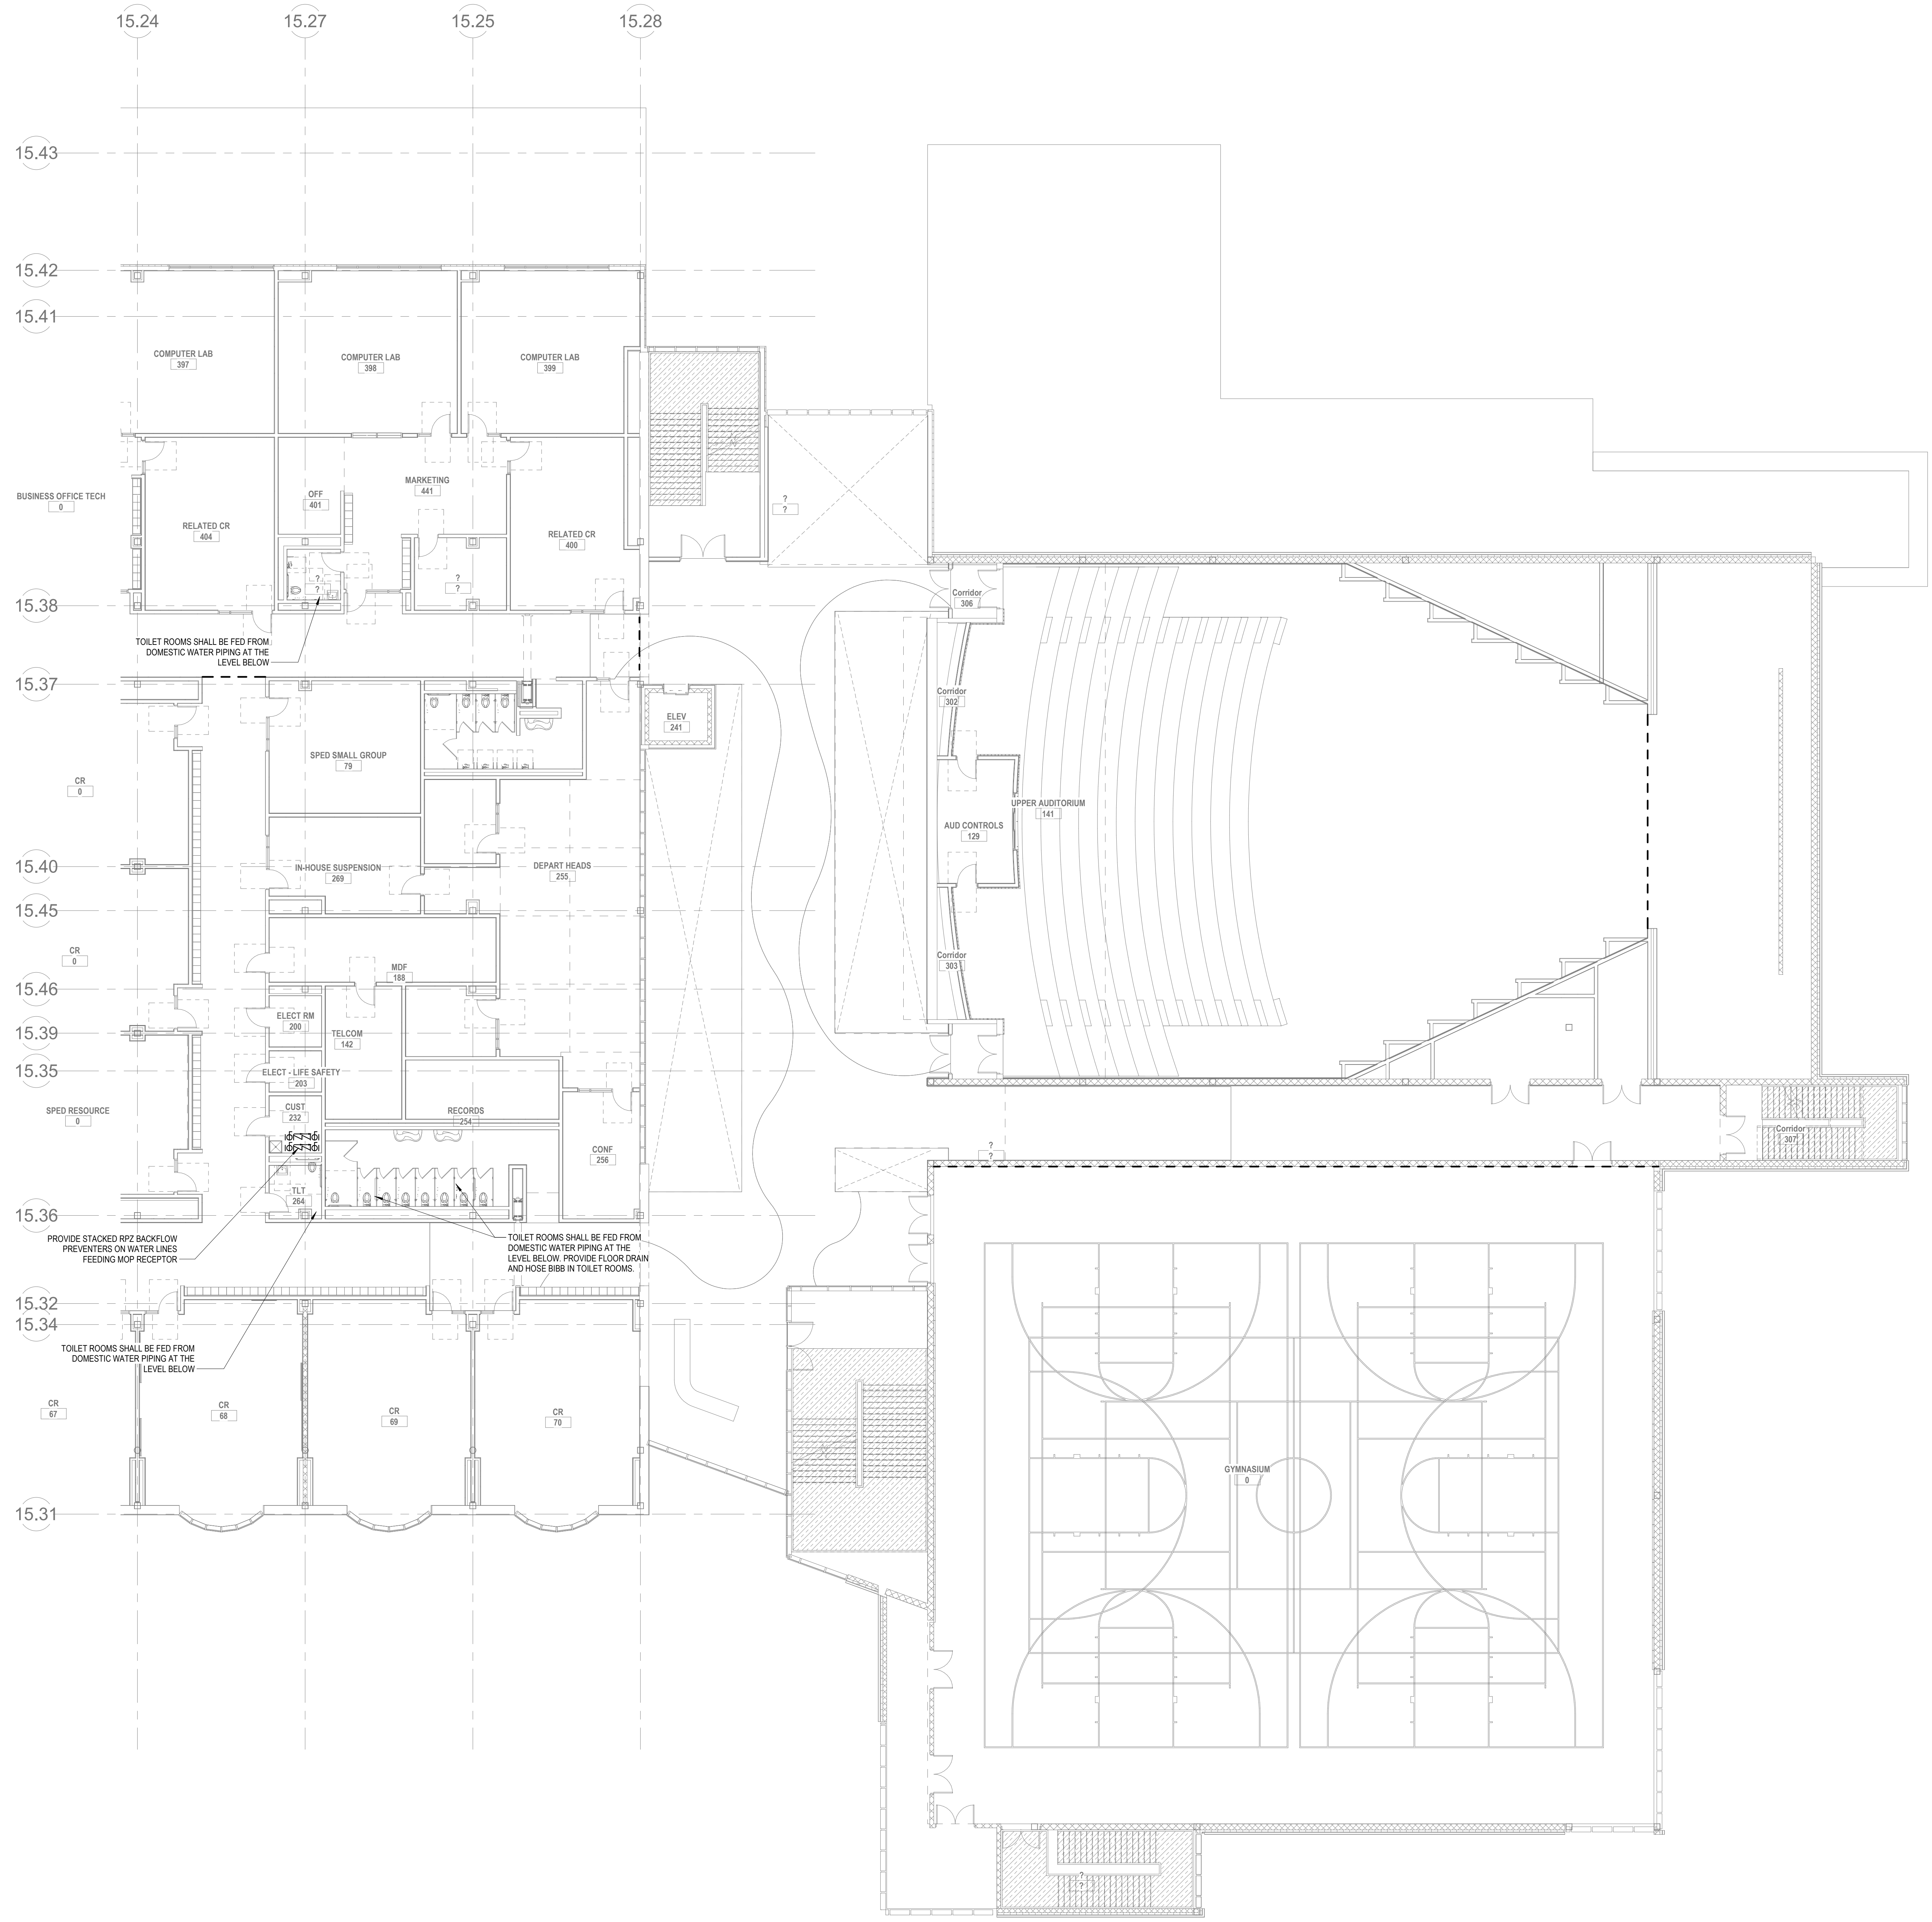

Drumme Rosane Anderson, Inc.
225 Oakland Road
Studio 205
South Windsor, CT 06074

260 Charles Street
Studio 300
Waltham, MA 02453

Planning | Architecture | Interior Design
Tel: 860.644.8300
www.dra.com

**NORTHEAST
METRO TECH**

100 Hemlock Rd.
Wakefield, MA 01880

BALA ENGINEERS

MSBA
SCHEMATIC
DESIGN
SUBMITTAL

JUNE 17, 2021

KEY PLAN

PROJECT NORTH

MAGNETIC NORTH

**PLUMBING
SECOND FLOOR
PLAN - PLAN
EAST**

Scale: 3/32" = 1'-0"

Job No.: 6020409

Drawn By: DRA

Date: JUNE 17, 2021

P1-1-2E

© COPYRIGHT 2021 DRUMMEY ROSANE ANDERSON, INC.

KEY NOTES:
1 OFF OF COMPRESSED AIR LOOP EXTEND COMPRESSED AIR DROP WITH ALL NECESSARY EQUIPMENT AIR OUTLET AS REQUIRED/NOTED PER EQUIPMENT DRAWINGS.

DRA

Drumrey Rosane Anderson, Inc.
225 Oakland Road
Studio 205
South Windsor, CT 06074
Tel: 860.644.8300
www.dra.com

260 Charles Street
Studio 300
Waltham, MA 02453
Tel: 860.644.8300
www.dra.com

Planning | Architecture | Interior Design

**NORTHEAST
METRO TECH**

100 Hemlock Rd.
Wakefield, MA 01880

BALA
ENGINEERS

MSBA
SCHEMATIC
DESIGN
SUBMITTAL



JUNE 17, 2021

A B C
D

KEY PLAN

PROJECT NORTH

MAGNETIC NORTH

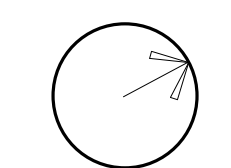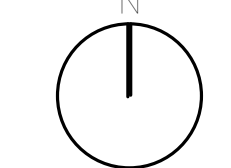

**PLUMBING
SECOND FLOOR
PLAN - PLAN
WEST**

Scale: 3/32" = 1'-0"

Job No.: 6020409

Drawn By: DRA

Date: JUNE 17, 2021

P1-1-2W

PLUMBING Level 2 West
P1-1-2W 3/32" = 1'-0"

Drummeys Rosane Anderson, Inc.

225 Oakland Road Studio 205 South Windsor, CT 06074	260 Charles Street Studio 300 Waltham, MA 02453
--	--

Planning | Architecture | Interior Design

Tel: 850.644.8300
www.draaas.com

100 Hemlock Rd,
Wakefield, MA 01880


MSBA
SCHEMATIC
DESIGN
SUBMITTAL

JUNE 17, 2021


KEY PLAN

Scale: $3/32" = 1'-0"$

P1-1-3E

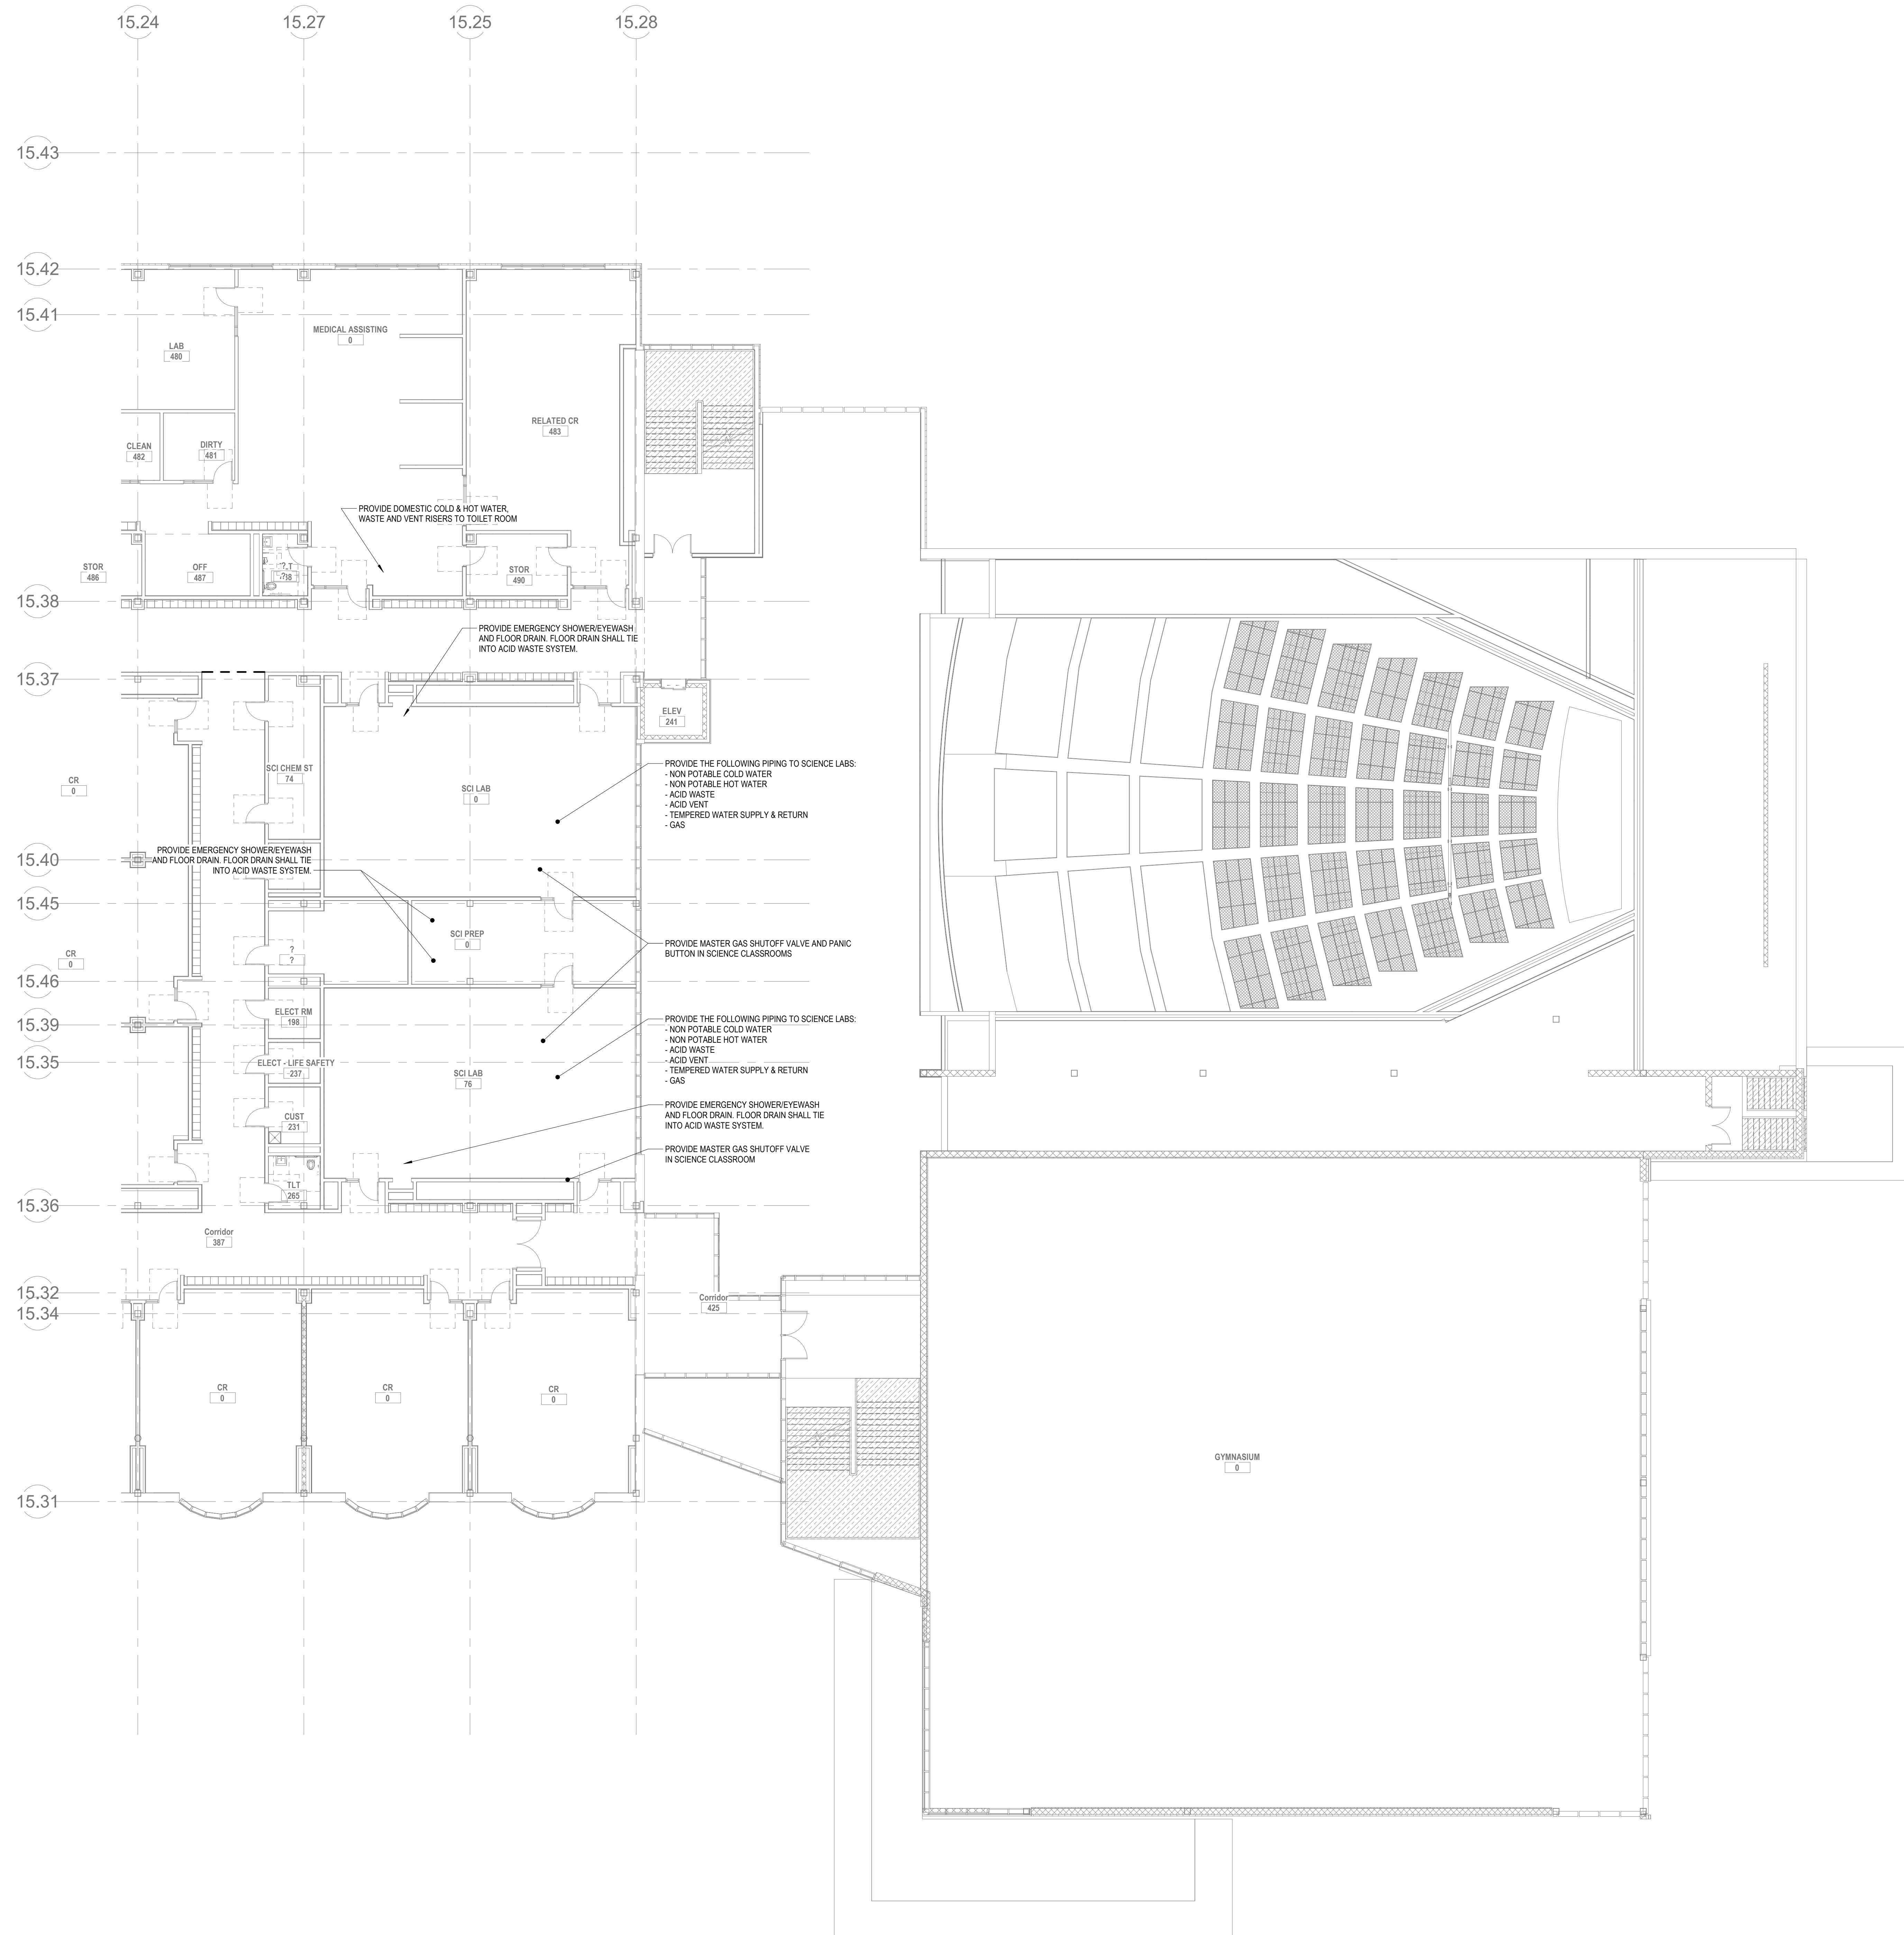

KEY NOTES:
1 OFF OF COMPRESSED AIR LOOP EXTEND COMPRESSED AIR DROP WITH ALL NECESSARY EQUIPMENT AIR OUTLET AS REQUIRED/NOTED PER EQUIPMENT DRAWINGS.

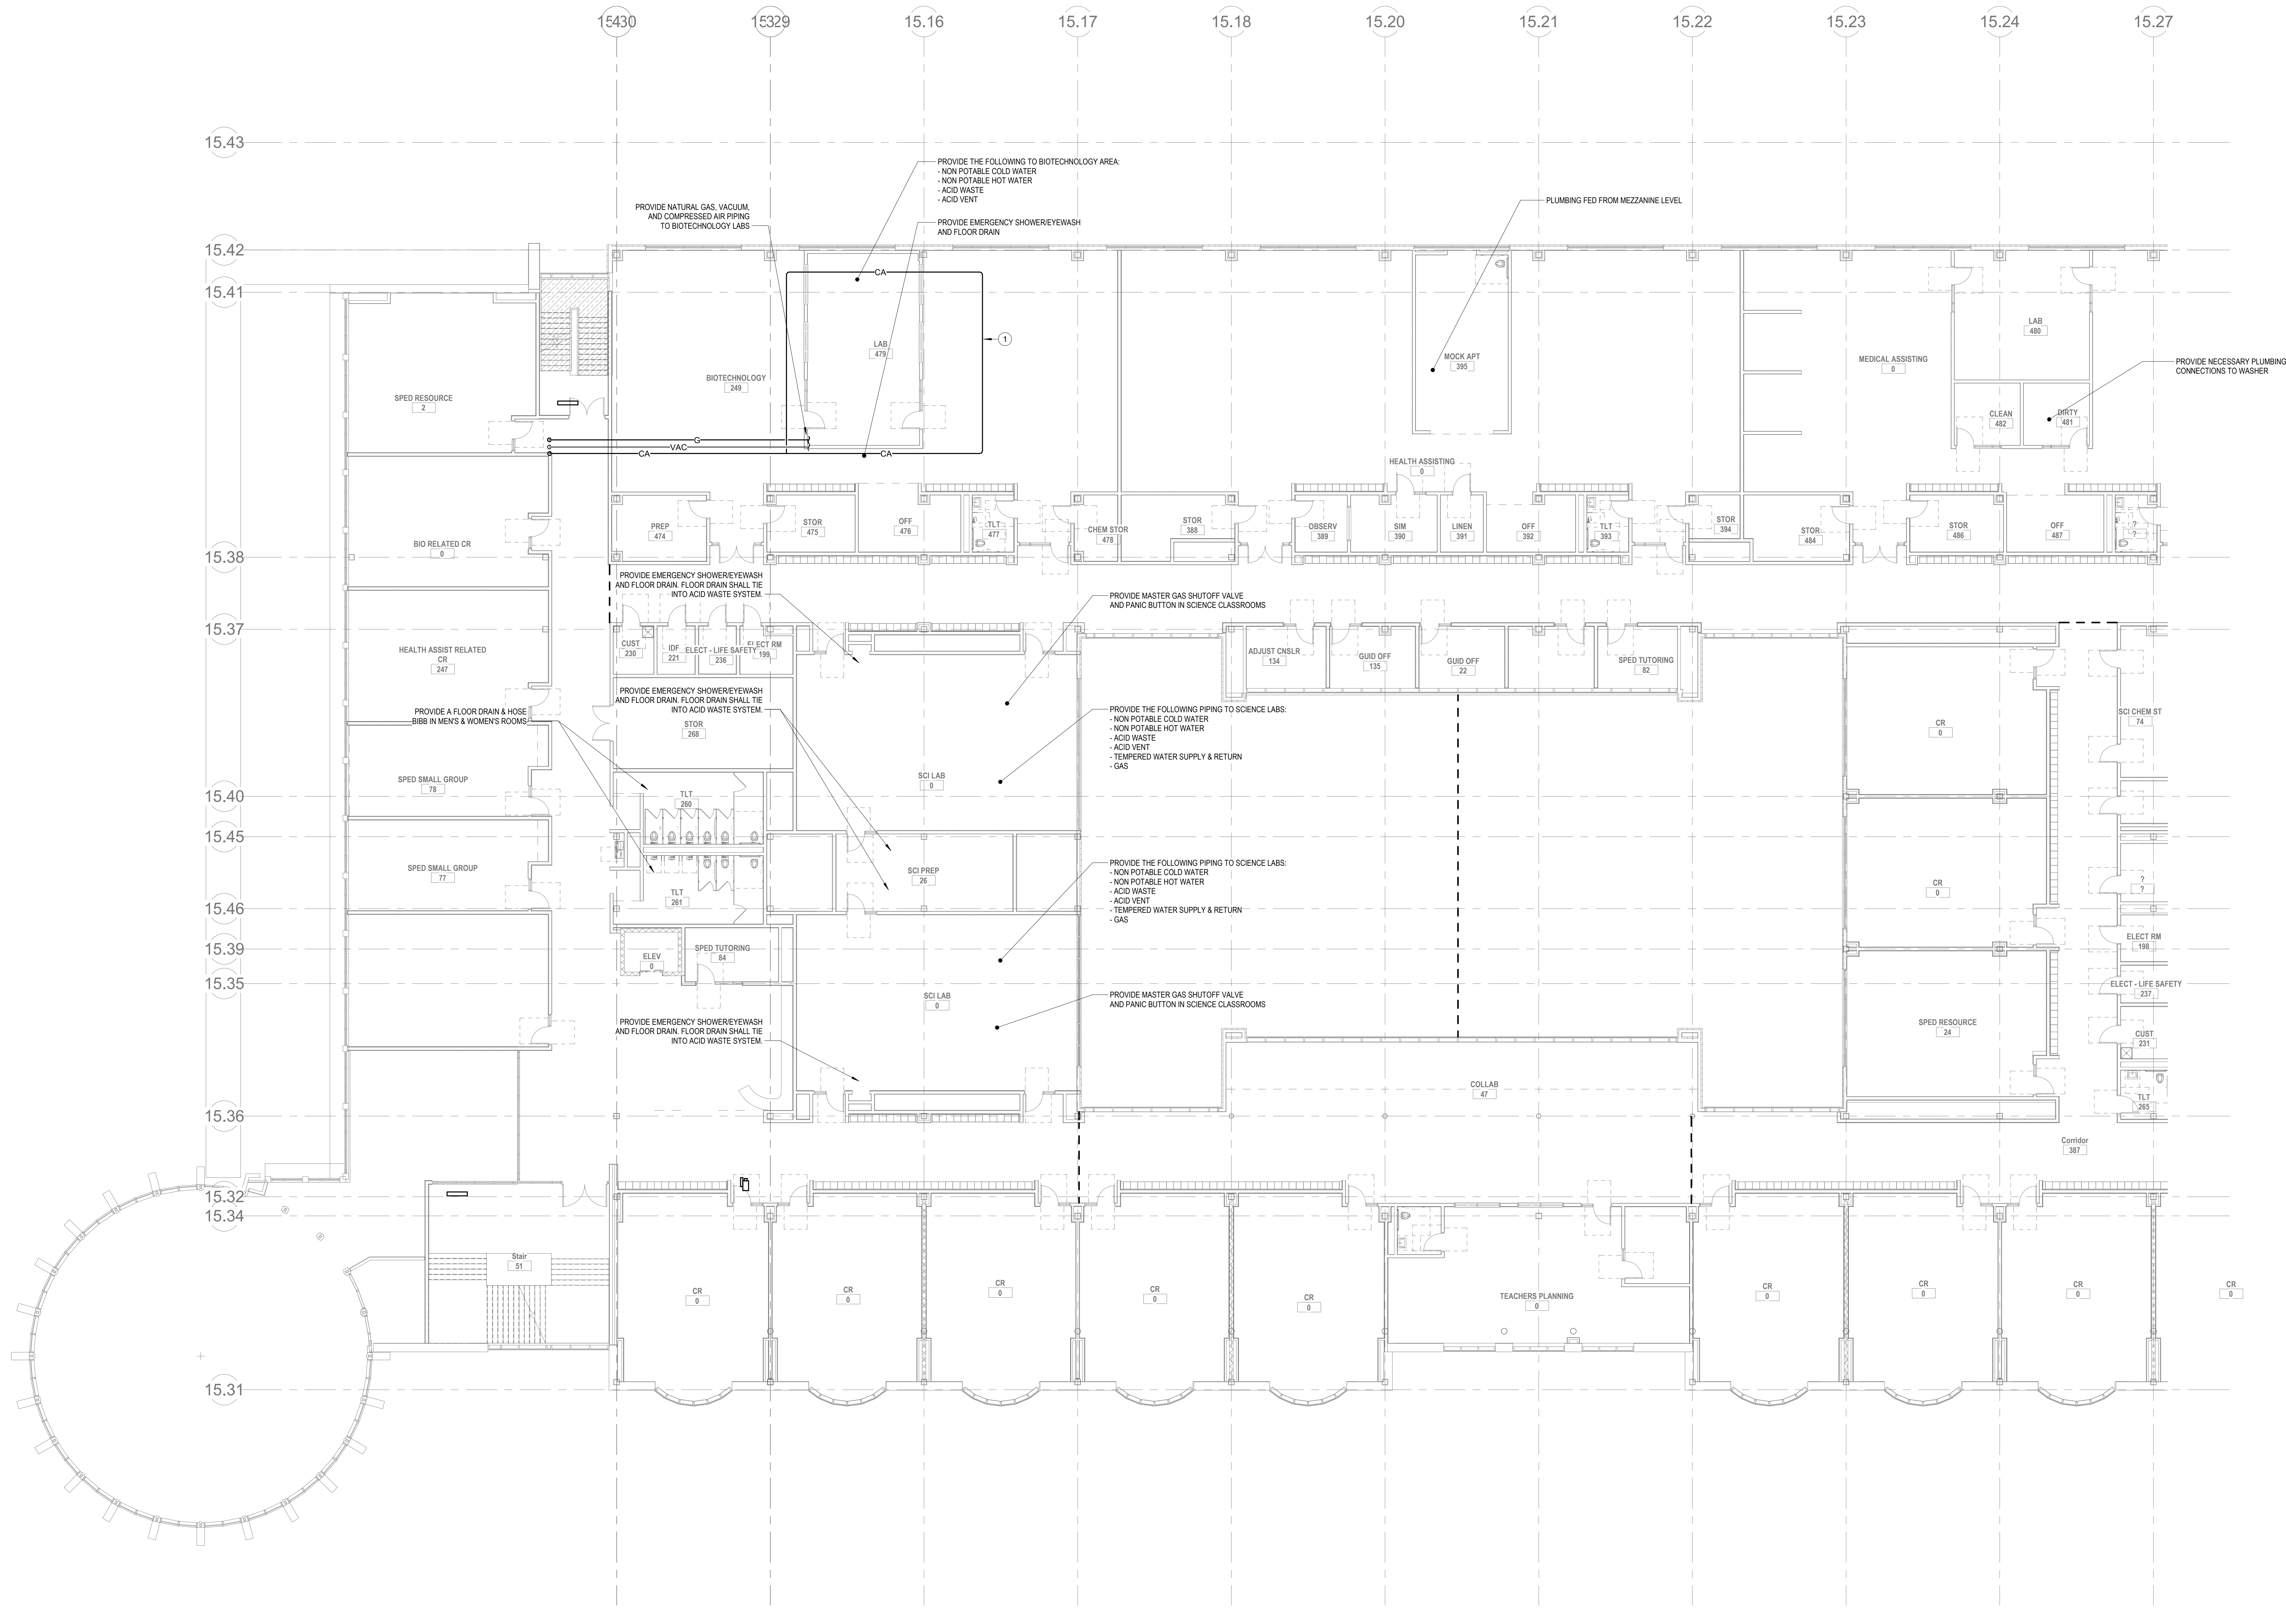

2 PLUMBING Level 3 West
P1-1-3W 3/22 - 1/0'

DRA

Drumrey Rosane Anderson, Inc.
225 Oakland Road
Studio 205
South Windsor, CT 06074
Tel: 860.644.8300
www.dra.com

260 Charles Street
Studio 300
Waltham, MA 02453
Tel: 860.644.8300
www.dra.com

NORTHEAST
METRO TECH


100 Hemlock Rd.
Wakefield, MA 01880

© COPYRIGHT 2021 DRUMREY ROSANE ANDERSON, INC.

BALA
ENGINEERS


MSBA
SCHEMATIC
DESIGN
SUBMITTAL

JUNE 17, 2021

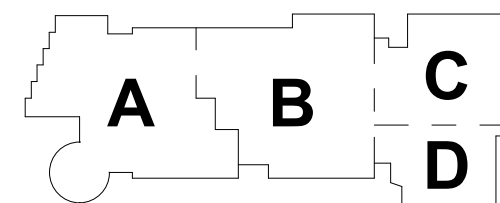


KEY PLAN

PROJECT NORTH

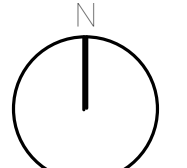

MAGNETIC NORTH

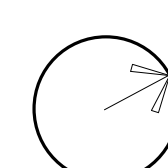

PLUMBING
THIRD FLOOR
PLAN - PLAN
WEST


Scale: 3/32" = 1'-0"

Job No.: 6520409

Drawn By: DRA

Date: JUNE 17, 2021

P1-1-3W

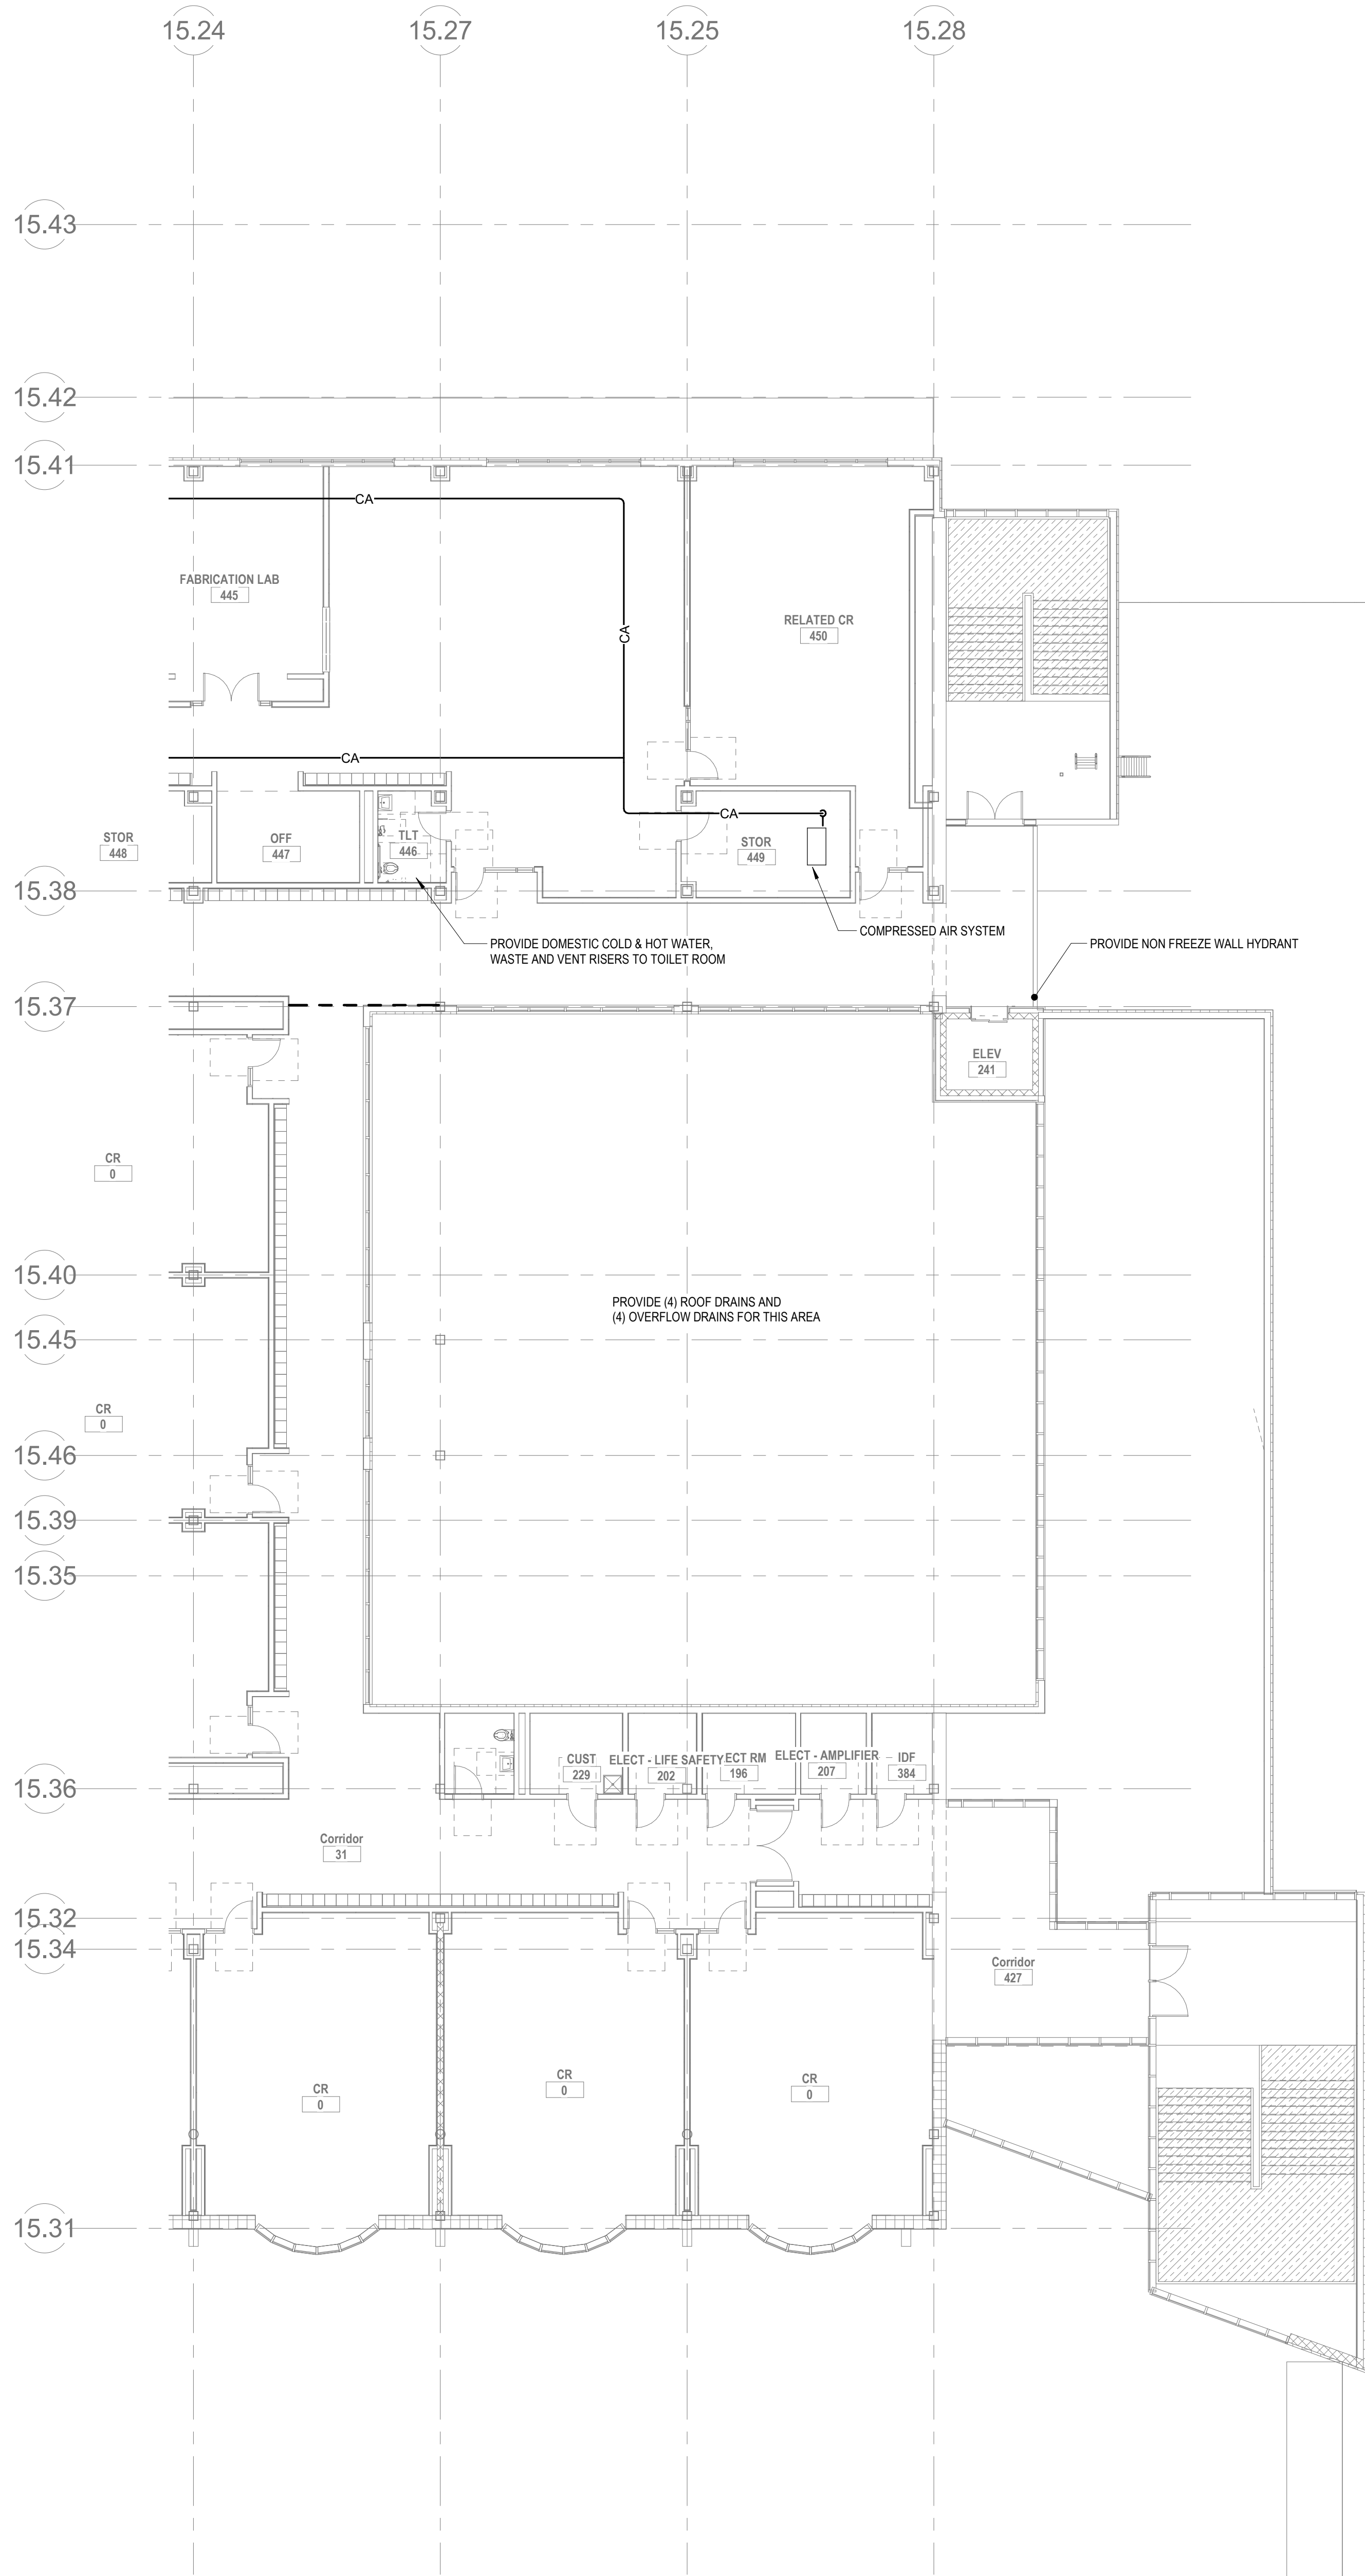

REFER TO ARCHITECTURAL DRAWINGS FOR LOCATIONS AND/OR PROVIDE AN ALLOWANCE FOR A MINIMUM OF (10) FLOOR DRAINS AND ALL ASSOCIATED PIPING

PLUMBING Level 4 East
P1-1-4E 3/32" = 1'-0"

DRA

Drumrey Rosane Anderson, Inc.
225 Oakland Road
Studio 205
South Windsor, CT
06074

260 Charles Street
Studio 300
Waltham, MA
02453

Planning | Architecture | Interior Design
Tel: 860.644.8300
www.dra-inc.com

NORTHEAST
METRO TECH

100 Hemlock Rd.
Wakefield, MA 01880


BALA
ENGINEERS

BALA ENGINEERS, INC.
100 STATE ST., 10TH FLOOR
BOSTON, MA 02109
TEL: 617.552.1000 FAX: 617.552.1001
WWW.BALAE.COM

REGISTERED PROFESSIONAL ENGINEERS
MASSACHUSETTS, NEW HAMPSHIRE, VERMONT, CONNECTICUT
ARCHITECTS, INTERIORS, LANDSCAPE ARCHITECTS
PLANNING, ENVIRONMENTAL ENGINEERS


MSBA
SCHEMATIC
DESIGN
SUBMITTAL

JUNE 17, 2021

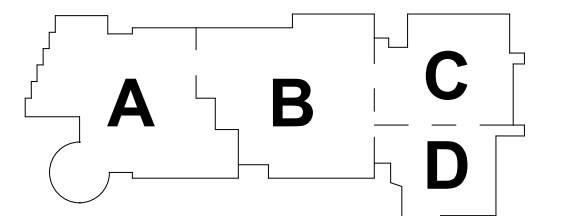


KEY PLAN

PROJECT NORTH

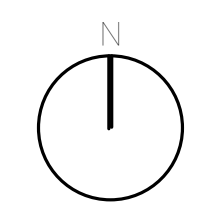

MAGNETIC NORTH

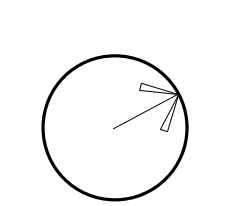

PLUMBING
FOURTH FLOOR
PLAN - PLAN
EAST

Scale: 3/32" = 1'-0"

Job No.: 6020409

Drawn By: DRA

Date: JUNE 17, 2021

P1-1-4E

DRA

Drumme Rosane Anderson, Inc.
225 Oakland Road
Studio 205
South Windsor, CT
06074
Tel: 860.644.8300
www.dra.com

260 Charles Street
Studio 300
Waltham, MA
02453
Tel: 860.644.8300
www.dra.com

Planning | Architecture | Interior Design

NORTHEAST
METRO TECH

100 Hemlock Rd.
Wakefield, MA 01880

BALA
ENGINEERS


MSBA
SCHEMATIC
DESIGN
SUBMITTAL

JUNE 17, 2021


A B C
D

KEY PLAN

PROJECT NORTH

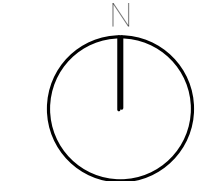

MAGNETIC NORTH

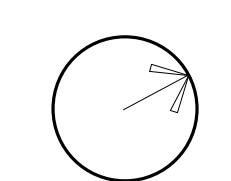

PLUMBING
FOURTH FLOOR
PLAN - PLAN
WEST


Scale: 3/32" = 1'-0"

Job No.: 6520409


Drawn By: DRA

Date: JUNE 17, 2021

P1-1-4W

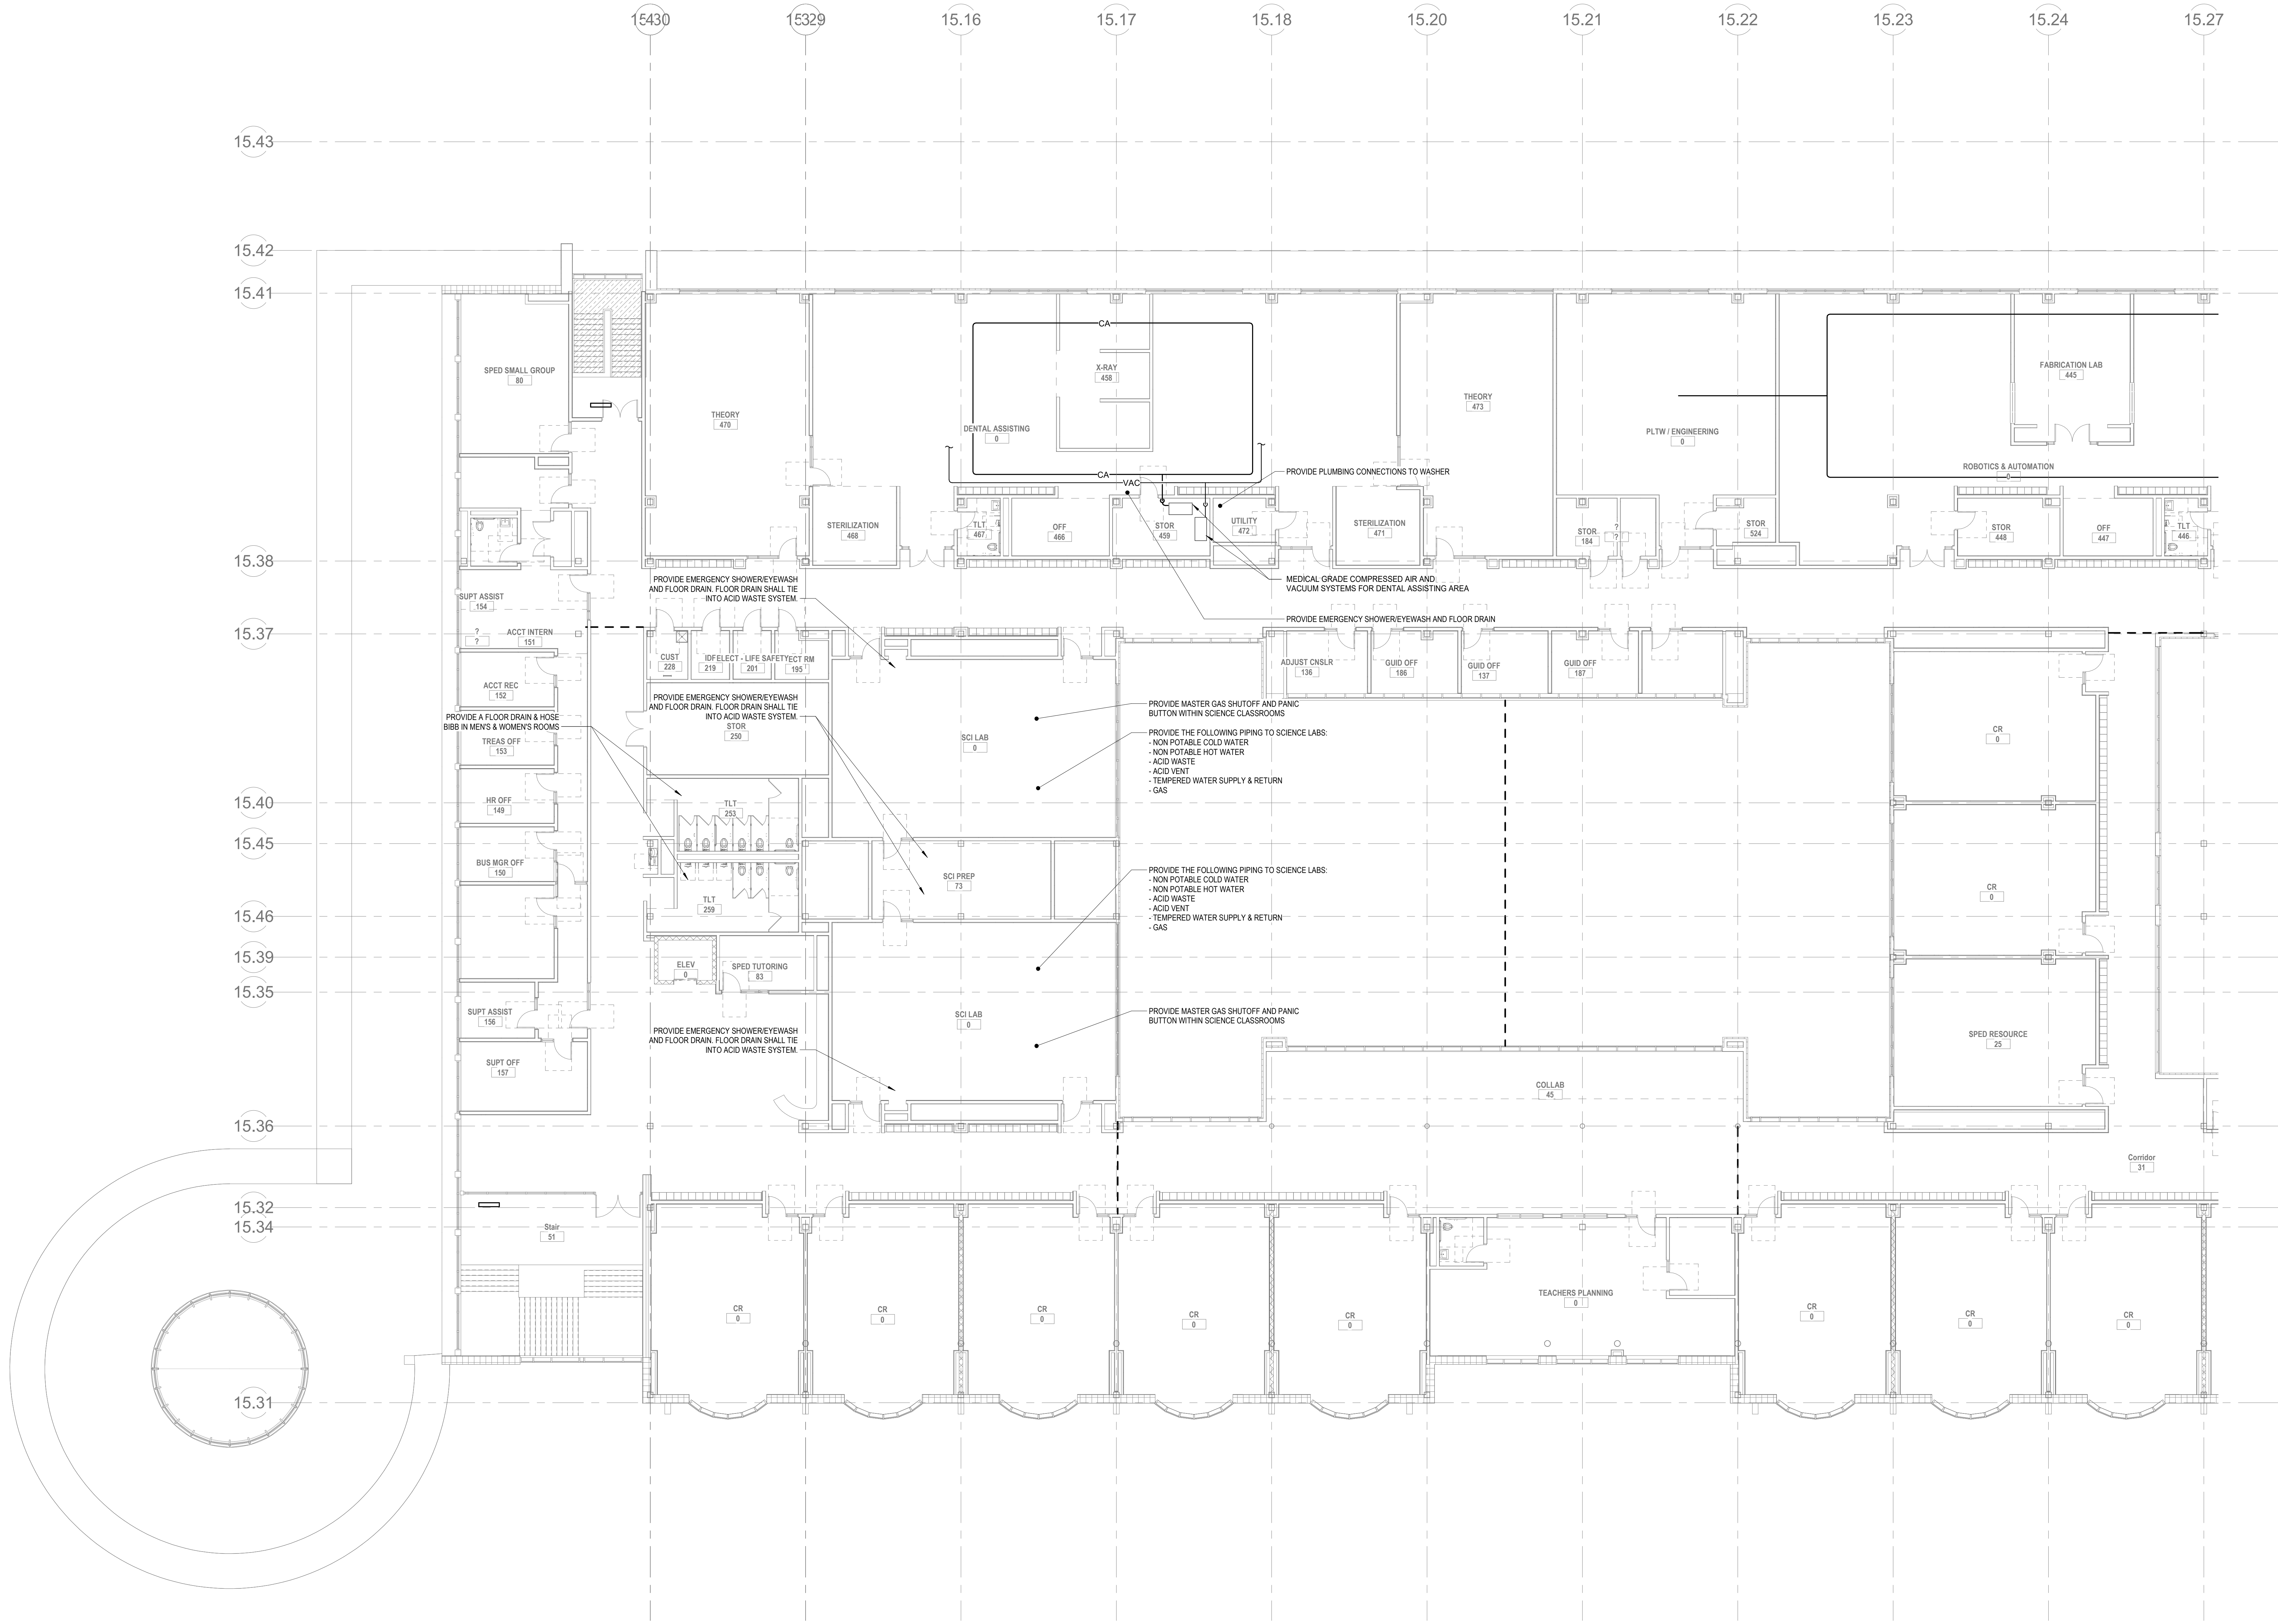

PLUMBING Level 4 West
P1-1-4W 3/32" = 1'-0"

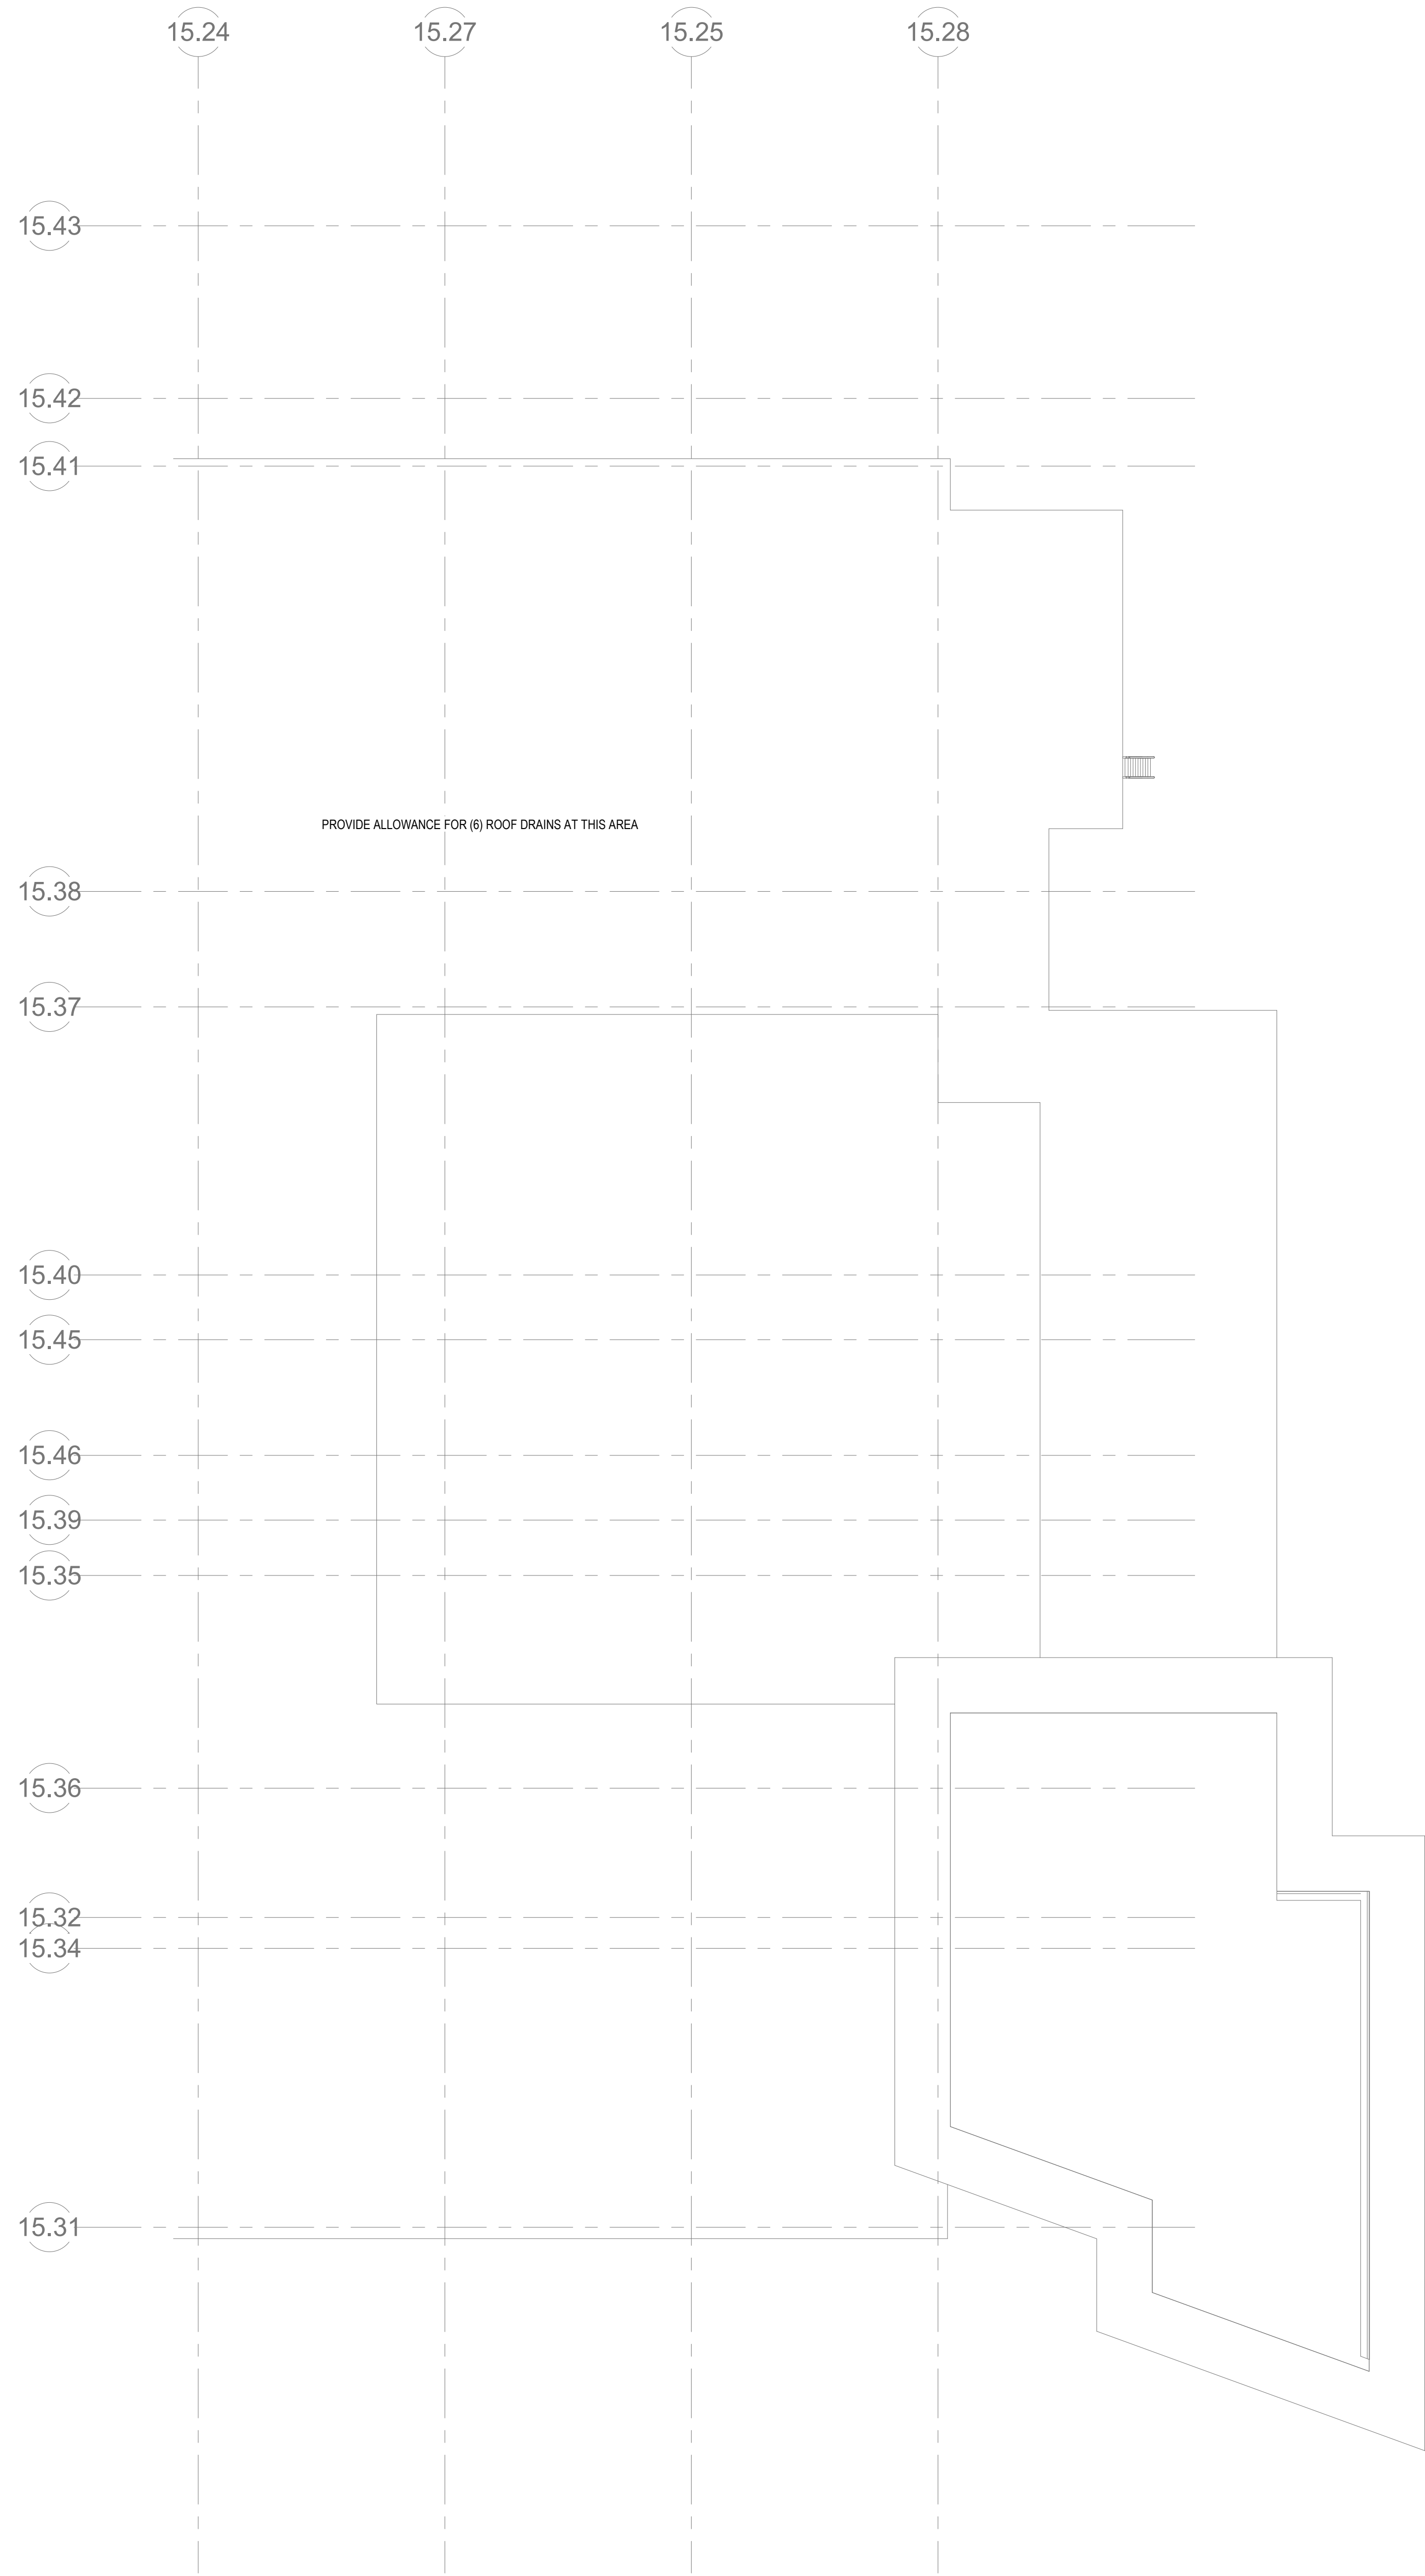

NOTE: IF AND WHERE REQUIRED, SECONDARY ROOF DRAINAGE SYSTEM TO BE HANDLED VIA SCUPPERS



Drumhey Rosane Anderson, Inc.
225 Oakland Road
Studio 205
South Windsor, CT 06074
260 Charles Street
Studio 300
Waltham, MA 02453
Planning | Architecture | Interior Design
Tel: 860.644.8300
www.dra-inc.com


NORTHEAST
METRO TECH

100 Hemlock Rd.
Wakefield, MA 01880




MSBA
SCHEMATIC
DESIGN
SUBMITTAL

JUNE 17, 2021

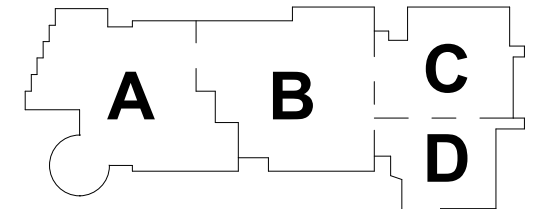


KEY PLAN

PROJECT NORTH

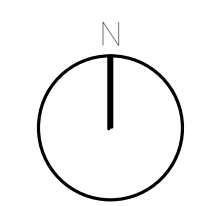

MAGNETIC NORTH

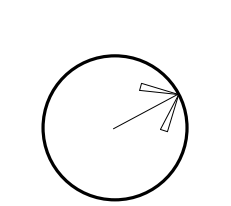

PLUMBING ROOF
PLAN - PLAN
EAST

Scale: 3/32" = 1'-0"
Job No.: 6520409
Drawn By: DRA
Date: JUNE 17, 2021

P1-2-1E

© COPYRIGHT 2021 DRUMHEY ROSANE ANDERSON, INC.



Drumhey Rosane Anderson, Inc.
225 Oakland Road
Studio 205
South Windsor, CT
06074
260 Charles Street
Studio 300
Waltham, MA
02453
Planning | Architecture | Interior Design
Tel: 860.644.8300
www.dra-inc.com


NORTHEAST
METRO TECH

100 Hemlock Rd.
Wakefield, MA 01880




MSBA
SCHEMATIC
DESIGN
SUBMITTAL

JUNE 17, 2021

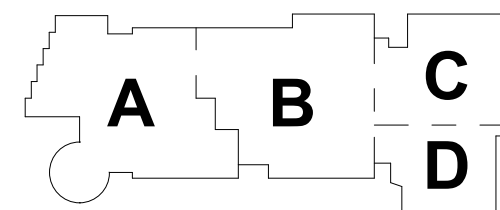


KEY PLAN

PROJECT NORTH

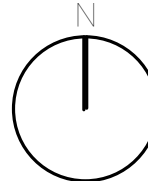


MAGNETIC NORTH

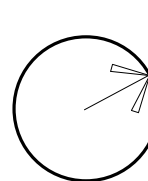

PLUMBING ROOF
PLAN - PLAN
WEST

Scale: 3/32" = 1'-0"
Job No.: 6520409
Drawn By: DRA
Date: JUNE 17, 2021

P1-2-1W

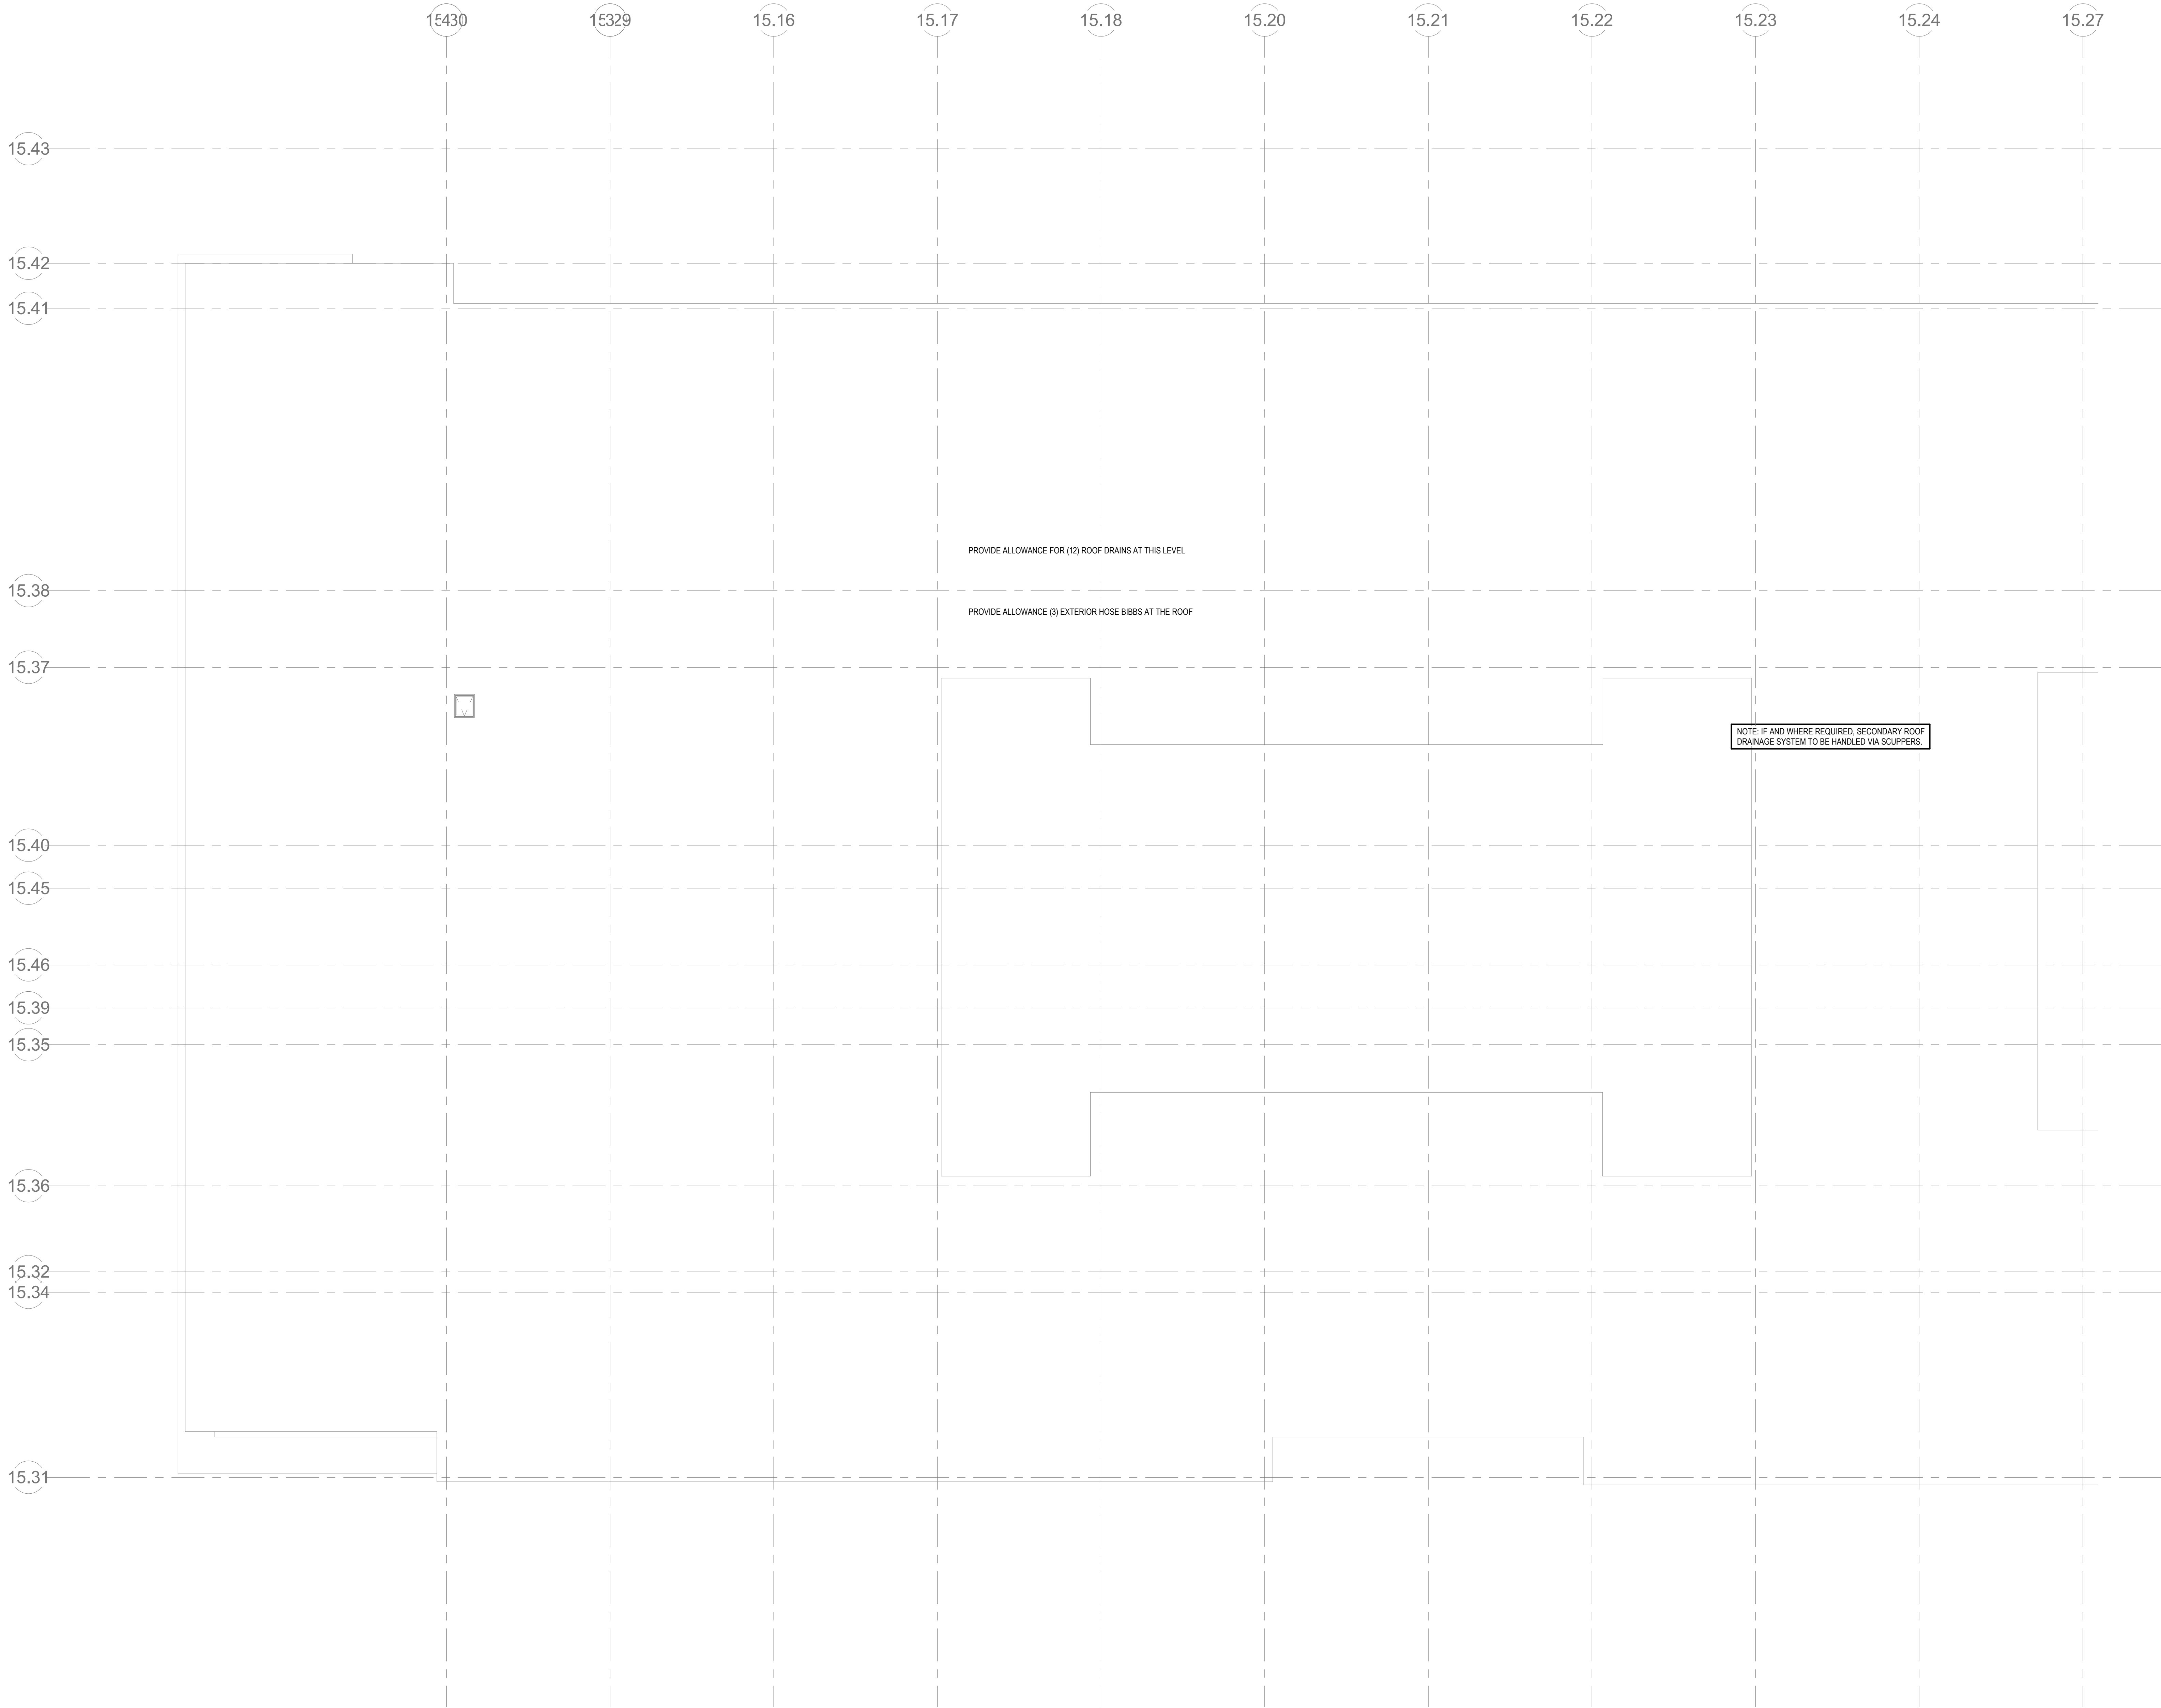

© COPYRIGHT 2021 DRUMHEY ROSANE ANDERSON, INC.